

Maya Gupta and Jim Muller Residence


INTERIOR RENOVATION Tuesday, February 13, 2018

SCOPE: INTERIOR RENOVATION OF EXISTING KITCHEN AND BATHROOMS. REPLACE ALL WINDOWS AND EXTERIOR DOORS. REMOVE ROOF FROM SIDE PORCH.

NOTE: CONTRACTOR TO BE RESPONSIBLE FOR PROPER EXECUTION AND COMPLETION OF PROJECT. ALL MEASUREMENTS ARE TO BE FIELD VERIFIED. CONSTRUCTION TO COMPLY WITH THE FOLLOWING CODES, AS WELL AS ALL LOCAL CODES.

- BUILDING: 2016 CALIFORNIA RESIDENTIAL CODE (IBC), WITH AMENDMENTS.
- FIRE SAFETY: 2016 CALIFORNIA FIRE CODE (IFC), WITH AMENDMENTS.
- PLUMBING: 2016 CALIFORNIA PLUMBING CODE (IPC), WITH AMENDMENTS.
- MECHANICAL: 2016 CALIFORNIA MECHANICAL CODE (IMC) WITH AMENDMENTS.
- ELECTRICAL: 2016 CALIFORNIA ELECTRICAL CODE
- CALGREEN: 2016 CALGREEN
- CA ENERGY: 2016 CALIFORNIA ENERGY CODE

Occupancy: Group R3/U
Type of Construction: YB
Fire Sprinklers Required: NO
Number of Stories: 2
A residential fire sprinkler system is not required in accordance with NFPA 13D and State and Local requirements.

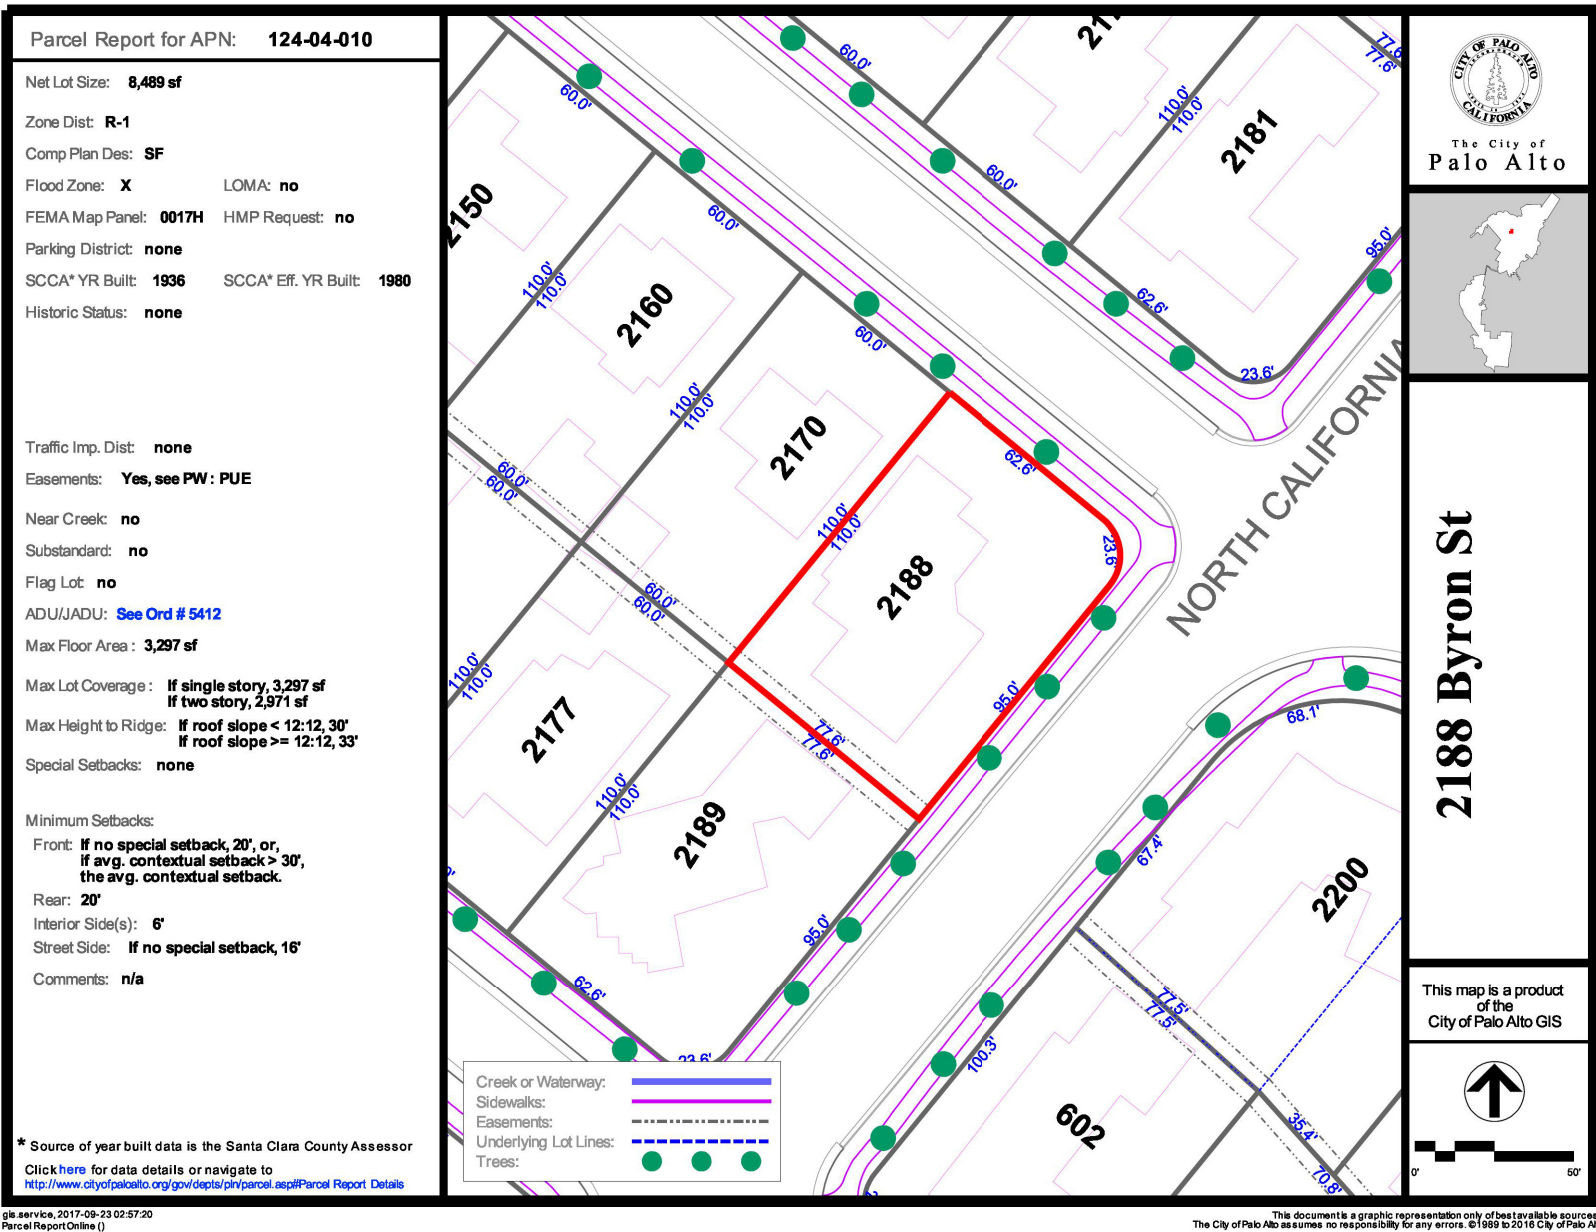

DRAWN BY: WHV
~ PHASE ~
DATE:
2/13/2018
REVISIONS:
DATE PRINTED: 2/13/2018 @ 6:33:01 PM

Efficient CAD
Anderson, CA 96007
Office: 404-502-1201
www.EfficientCAD.com
William@EfficientCAD.com

Efficient CAD

DRAWING INDEX

- | | |
|--------|----------------------------|
| A0.0 | COVER |
| AB.1 | EXISTING MAIN FLOOR |
| AB.2 | EXISTING UPPER LEVEL |
| AB 3-4 | EXISTING ELECTRICAL PLANS |
| AB 5-6 | EXISTING ELEVATIONS |
| AB7 | EXISTING SECTIONS |
| A1.1 | PROPOSED MAIN FLOOR |
| A2.1 | PROPOSED UPPER LEVEL |
| A3-4 | PROPOSED ELEVATIONS |
| A5 | CABINET ELEVATIONS |
| ROOF | EXISTING AND PROPOSED ROOF |
| E1-2 | PROPOSED ELECTRICAL |

24-HOUR CONTACT

NAME: John Montoya
ADDRESS: KANLER
995 Marsh Rd
Redwood City, CA 94063
PHONE: 1 (844) 208-9300
EMAIL: alan@kanler.com
WEBSITE: kanler.com

RELEASED FOR
CONSTRUCTION




VICINITY MAP

Maya Gupta and Jim
Muller Residence
2188 BYRON ST.
PALO ALTO, CA 94301


A0.0

1 of 24

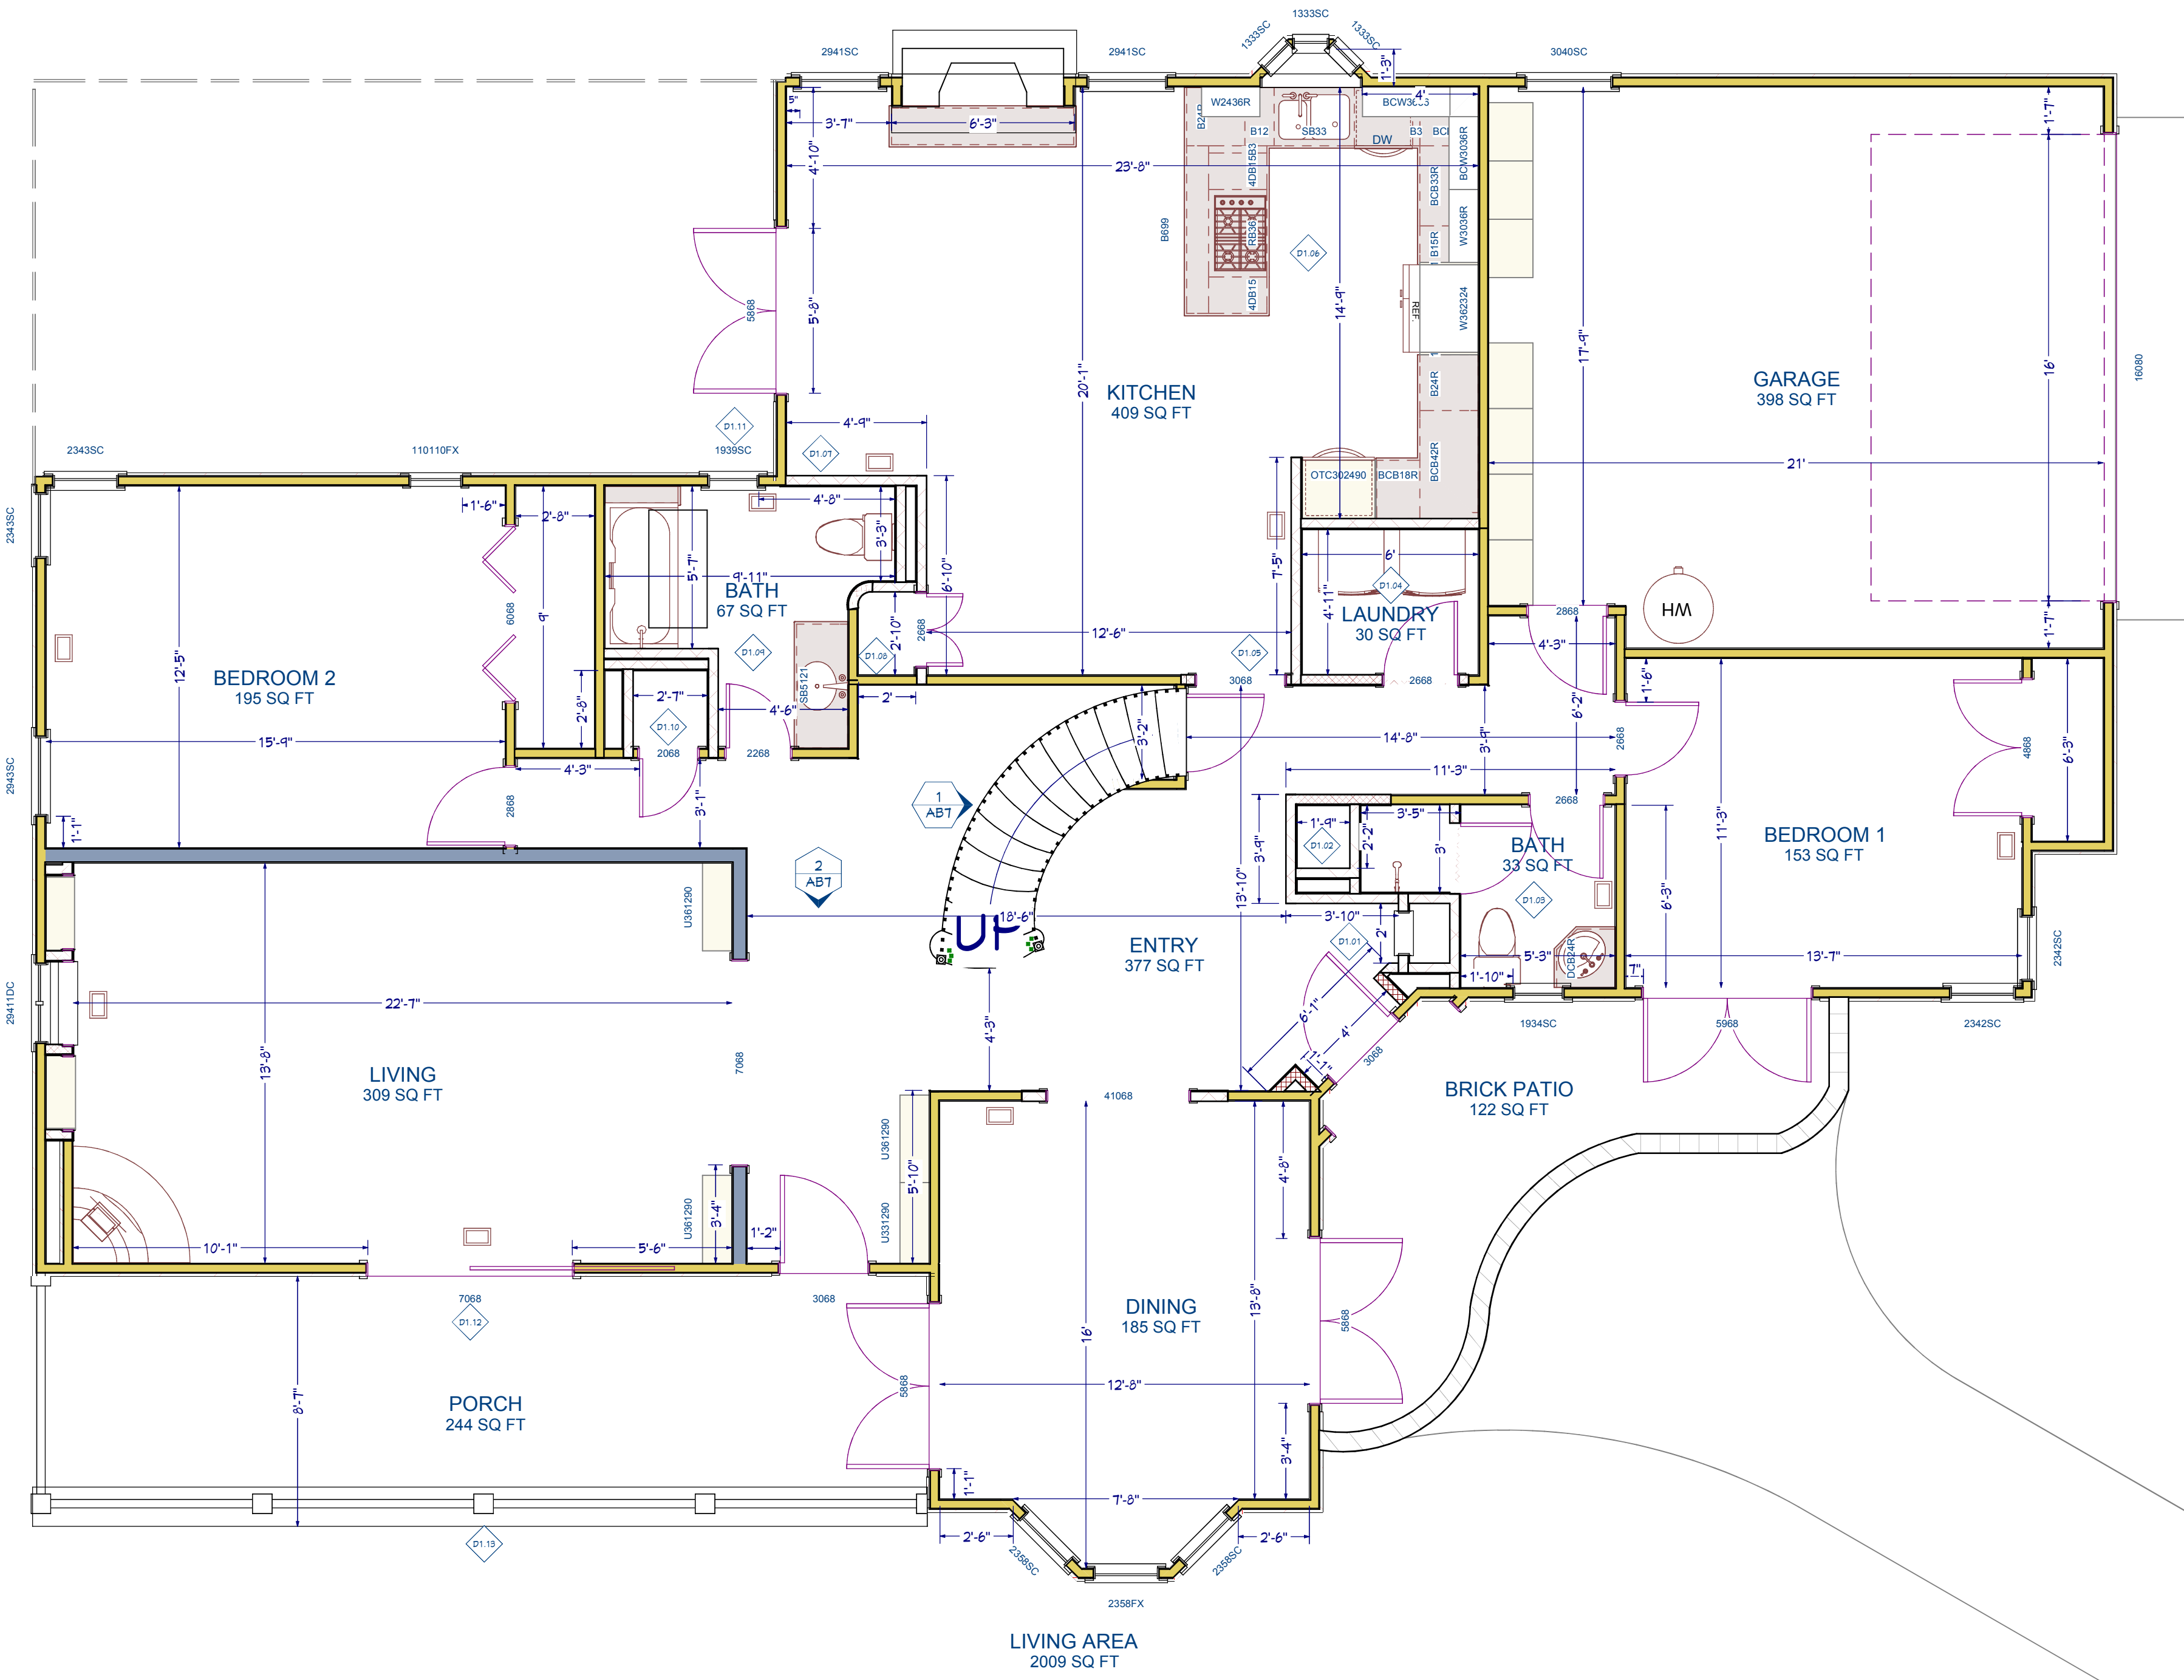


EXISTING GROUND LEVEL

WALL TYPES		DRAWN BY: WHV	
	EXTERIOR WALL	~ PHASE ~	
	INTERIOR WALL	DATE: 2/13/2018	
	DEMOLITION WALL	REVISIONS:	
DEMOLITION NOTES		DATE PRINTED: 2/13/2018 @ 6:33:01 PM	
	D1.01 DEMO NICHE	Efficient CAD Anderson, CA 96007 Office: 404-502-1201 www.EfficientCAD.com William@EfficientCAD.com	
	D1.02 DEMO CLOSET & RE-ROUT PLUMBING CHASE		
	D1.03 DEMO BATH FIXTURES, TILE AND ACCESSORIES		
	D1.04 DEMO LAUNDRY FIXTURES, DOORS AND WALLS		
	D1.05 WIDEN DOORWAY		
	D1.06 DEMO KITCHEN FIXTURES, CABINETS AND COUNTERS		
	D1.07 RELOCATE 2 KITCHEN FLOOR VENTS		
	D1.08 DEMO PANTRY WALLS AND DOORS		
	D1.09 DEMO BATHROOM FIXTURES AND WALLS		
	D1.10 RESIZE CLOSET AND CLOSET DOOR		
	D1.11 DEMO AND RESIZE WINDOW		
	D1.12 DEMO EXTERIOR POCKET DOOR		
	D1.13 DEMO PORCH ROOF AS NEEDED PER PROPOSED PLANS		
	D1.14 RESIZE BAY WINDOWS AND REPLACE		
	D1.15 REPLACE ALL EXTERIOR DOORS AND WINDOWS, EXCEPT FRONT DOOR		
		Maya Gupta and Jim Muller Residence 2188 BYRON ST. PALO ALTO, CA 94301	
		AB.1	
		2 of 24	

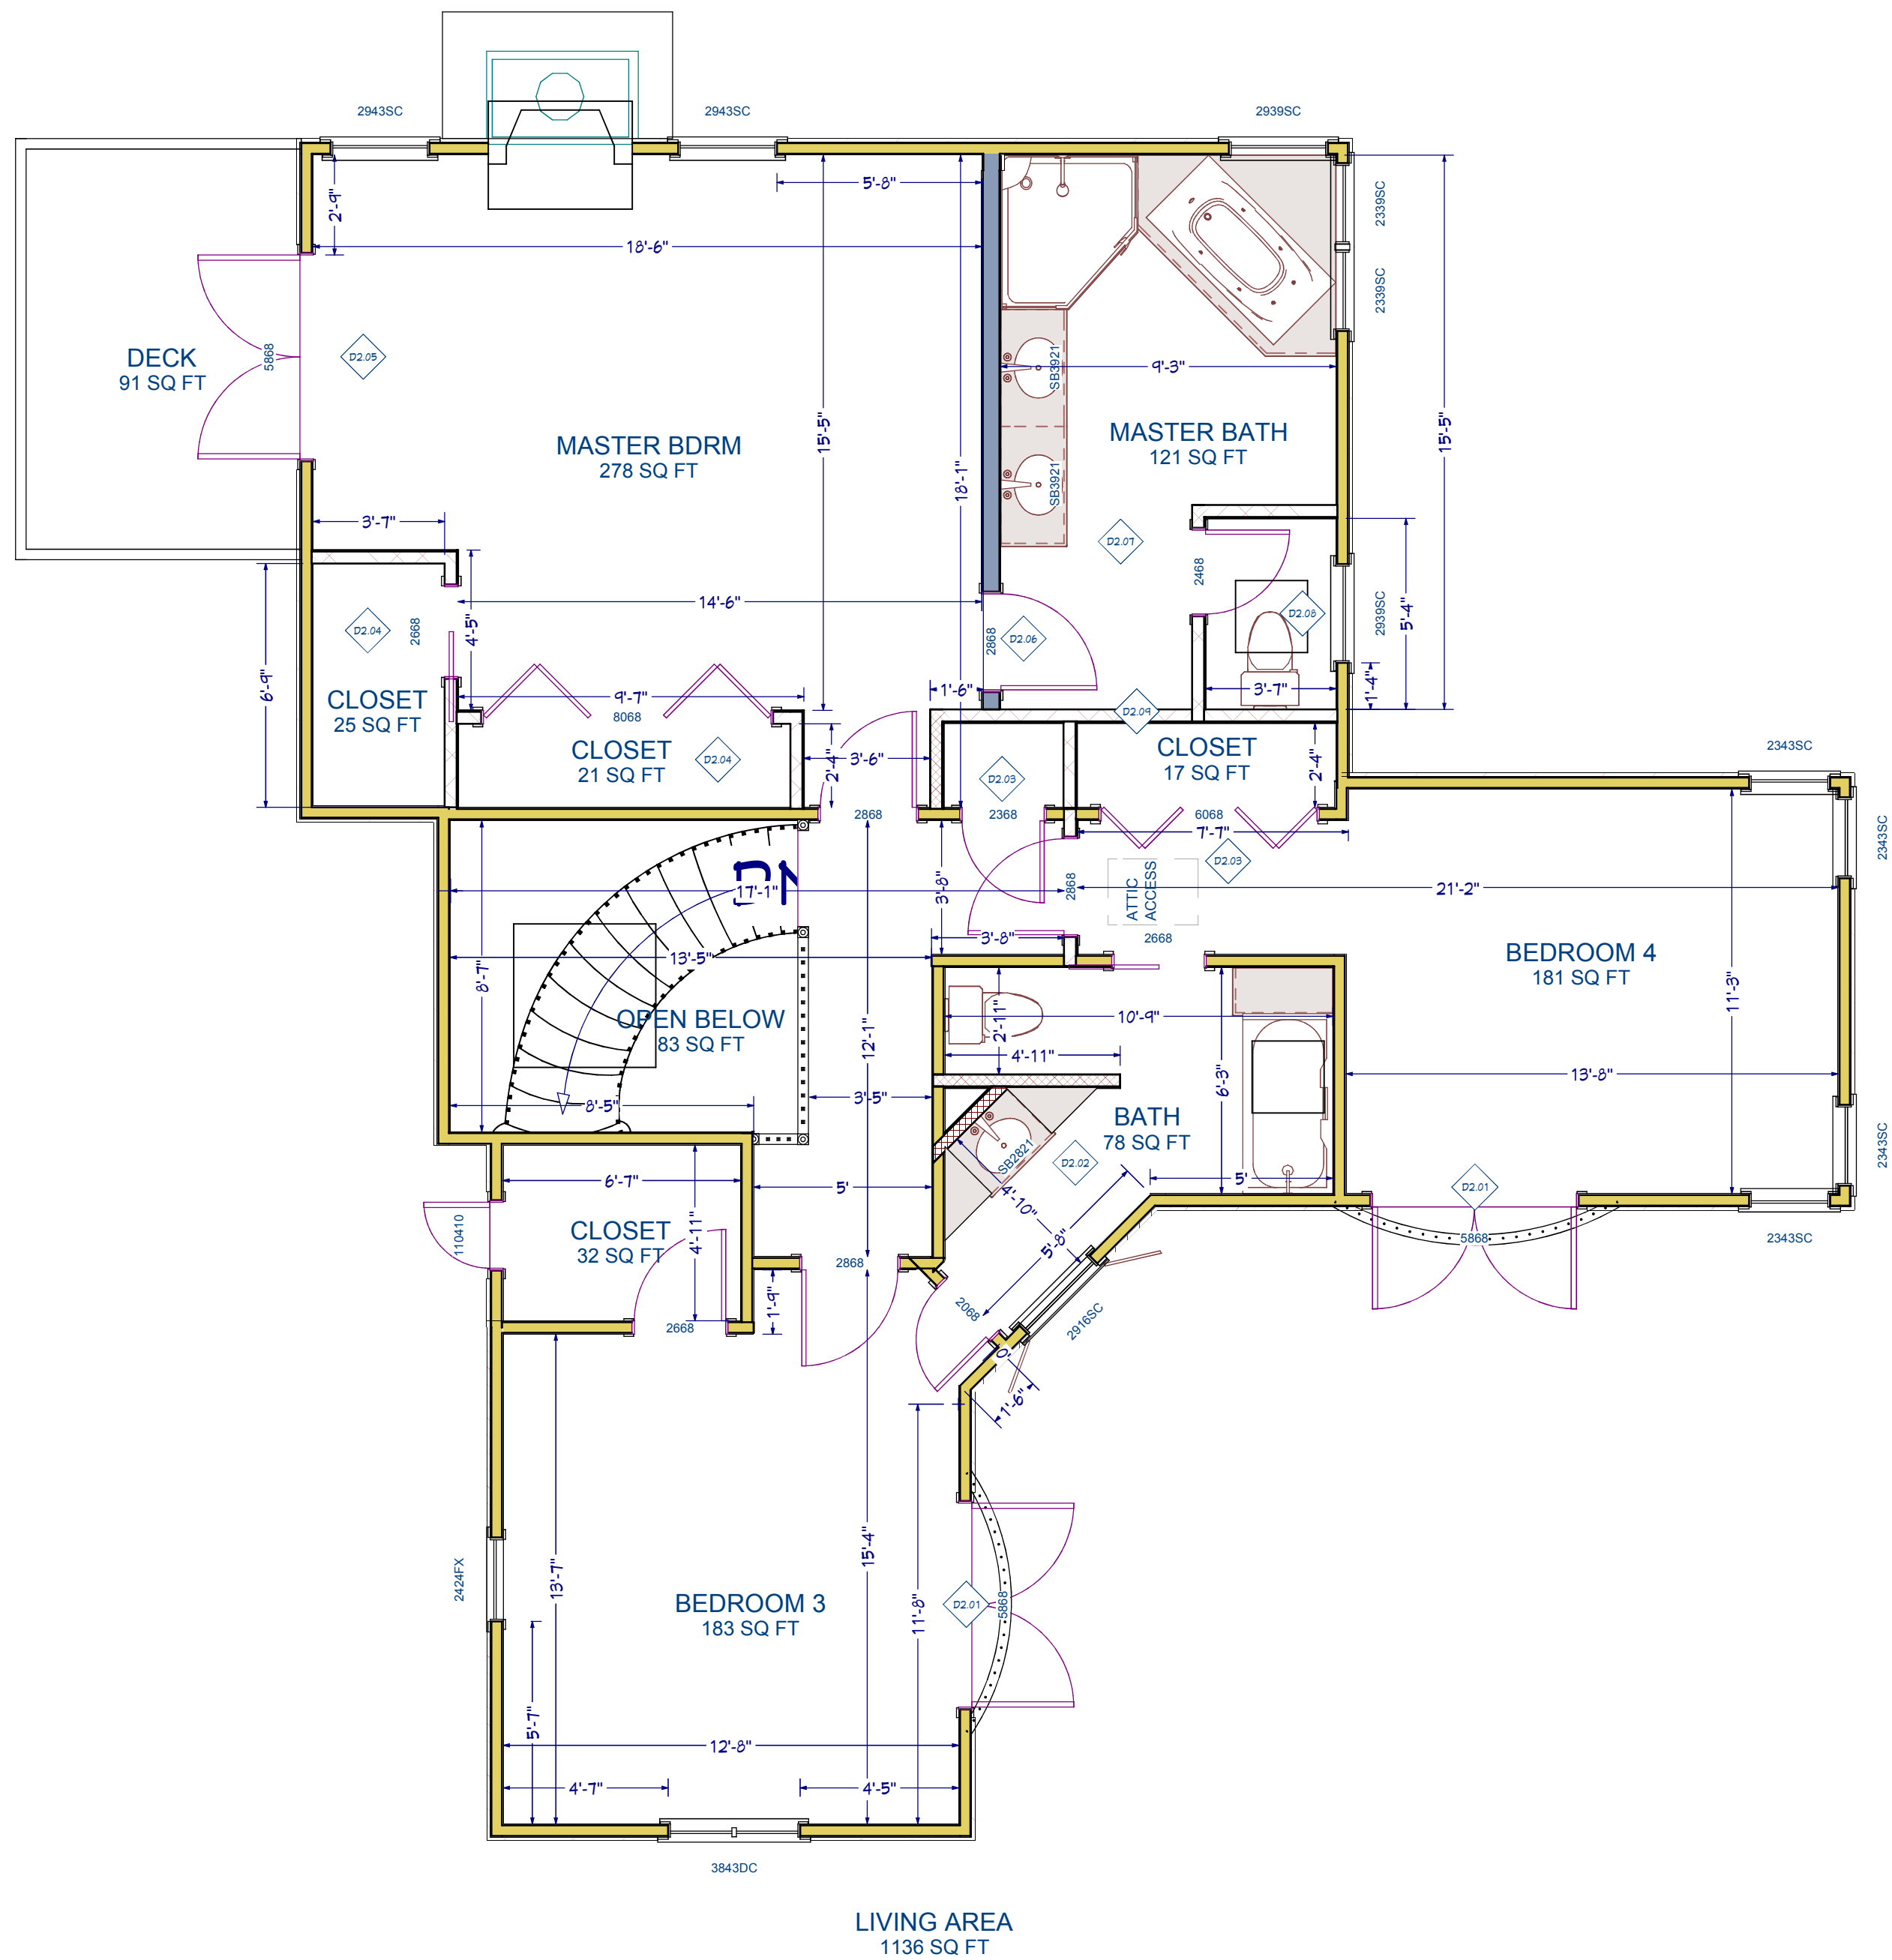

EXISTING UPPER LEVEL


WALL TYPES		DRAWN BY: WHV	
EXTERIOR WALL		~ PHASE ~	
INTERIOR WALL		DATE: 2/13/2018	
DEMOLITION WALL		REVISIONS:	
DEMOLITION NOTES		DATE PRINTED: 2/13/2018 @ 6:33:02 PM	
D2.01 REMOVE DOORS		Efficient CAD Anderson, CA 96007 Office: 404-502-1201 www.EfficientCAD.com William@EfficientCAD.com	
D2.02 DEMO BATHROOM TILE AND FIXTURES			
D2.03 REMOVE CLOSET DOORS			
D2.04 DEMO CLOSETS			
D2.05 REMOVE FRENCH DOORS			
D2.06 MOVE DOORWAY			
D2.07 DEMO MASTER BATH TILE AND FIXTURES			
D2.08 REMOVE WINDOW AND PATCH STUCCO			
D2.09 VERIFY THAT WALL IS NOT LOAD BEARING			
		Efficient CAD	
		Maya Gupta and Jim Muller Residence 2188 BYRON ST. PALO ALTO, CA 94301	
AB.2		3 of 24	

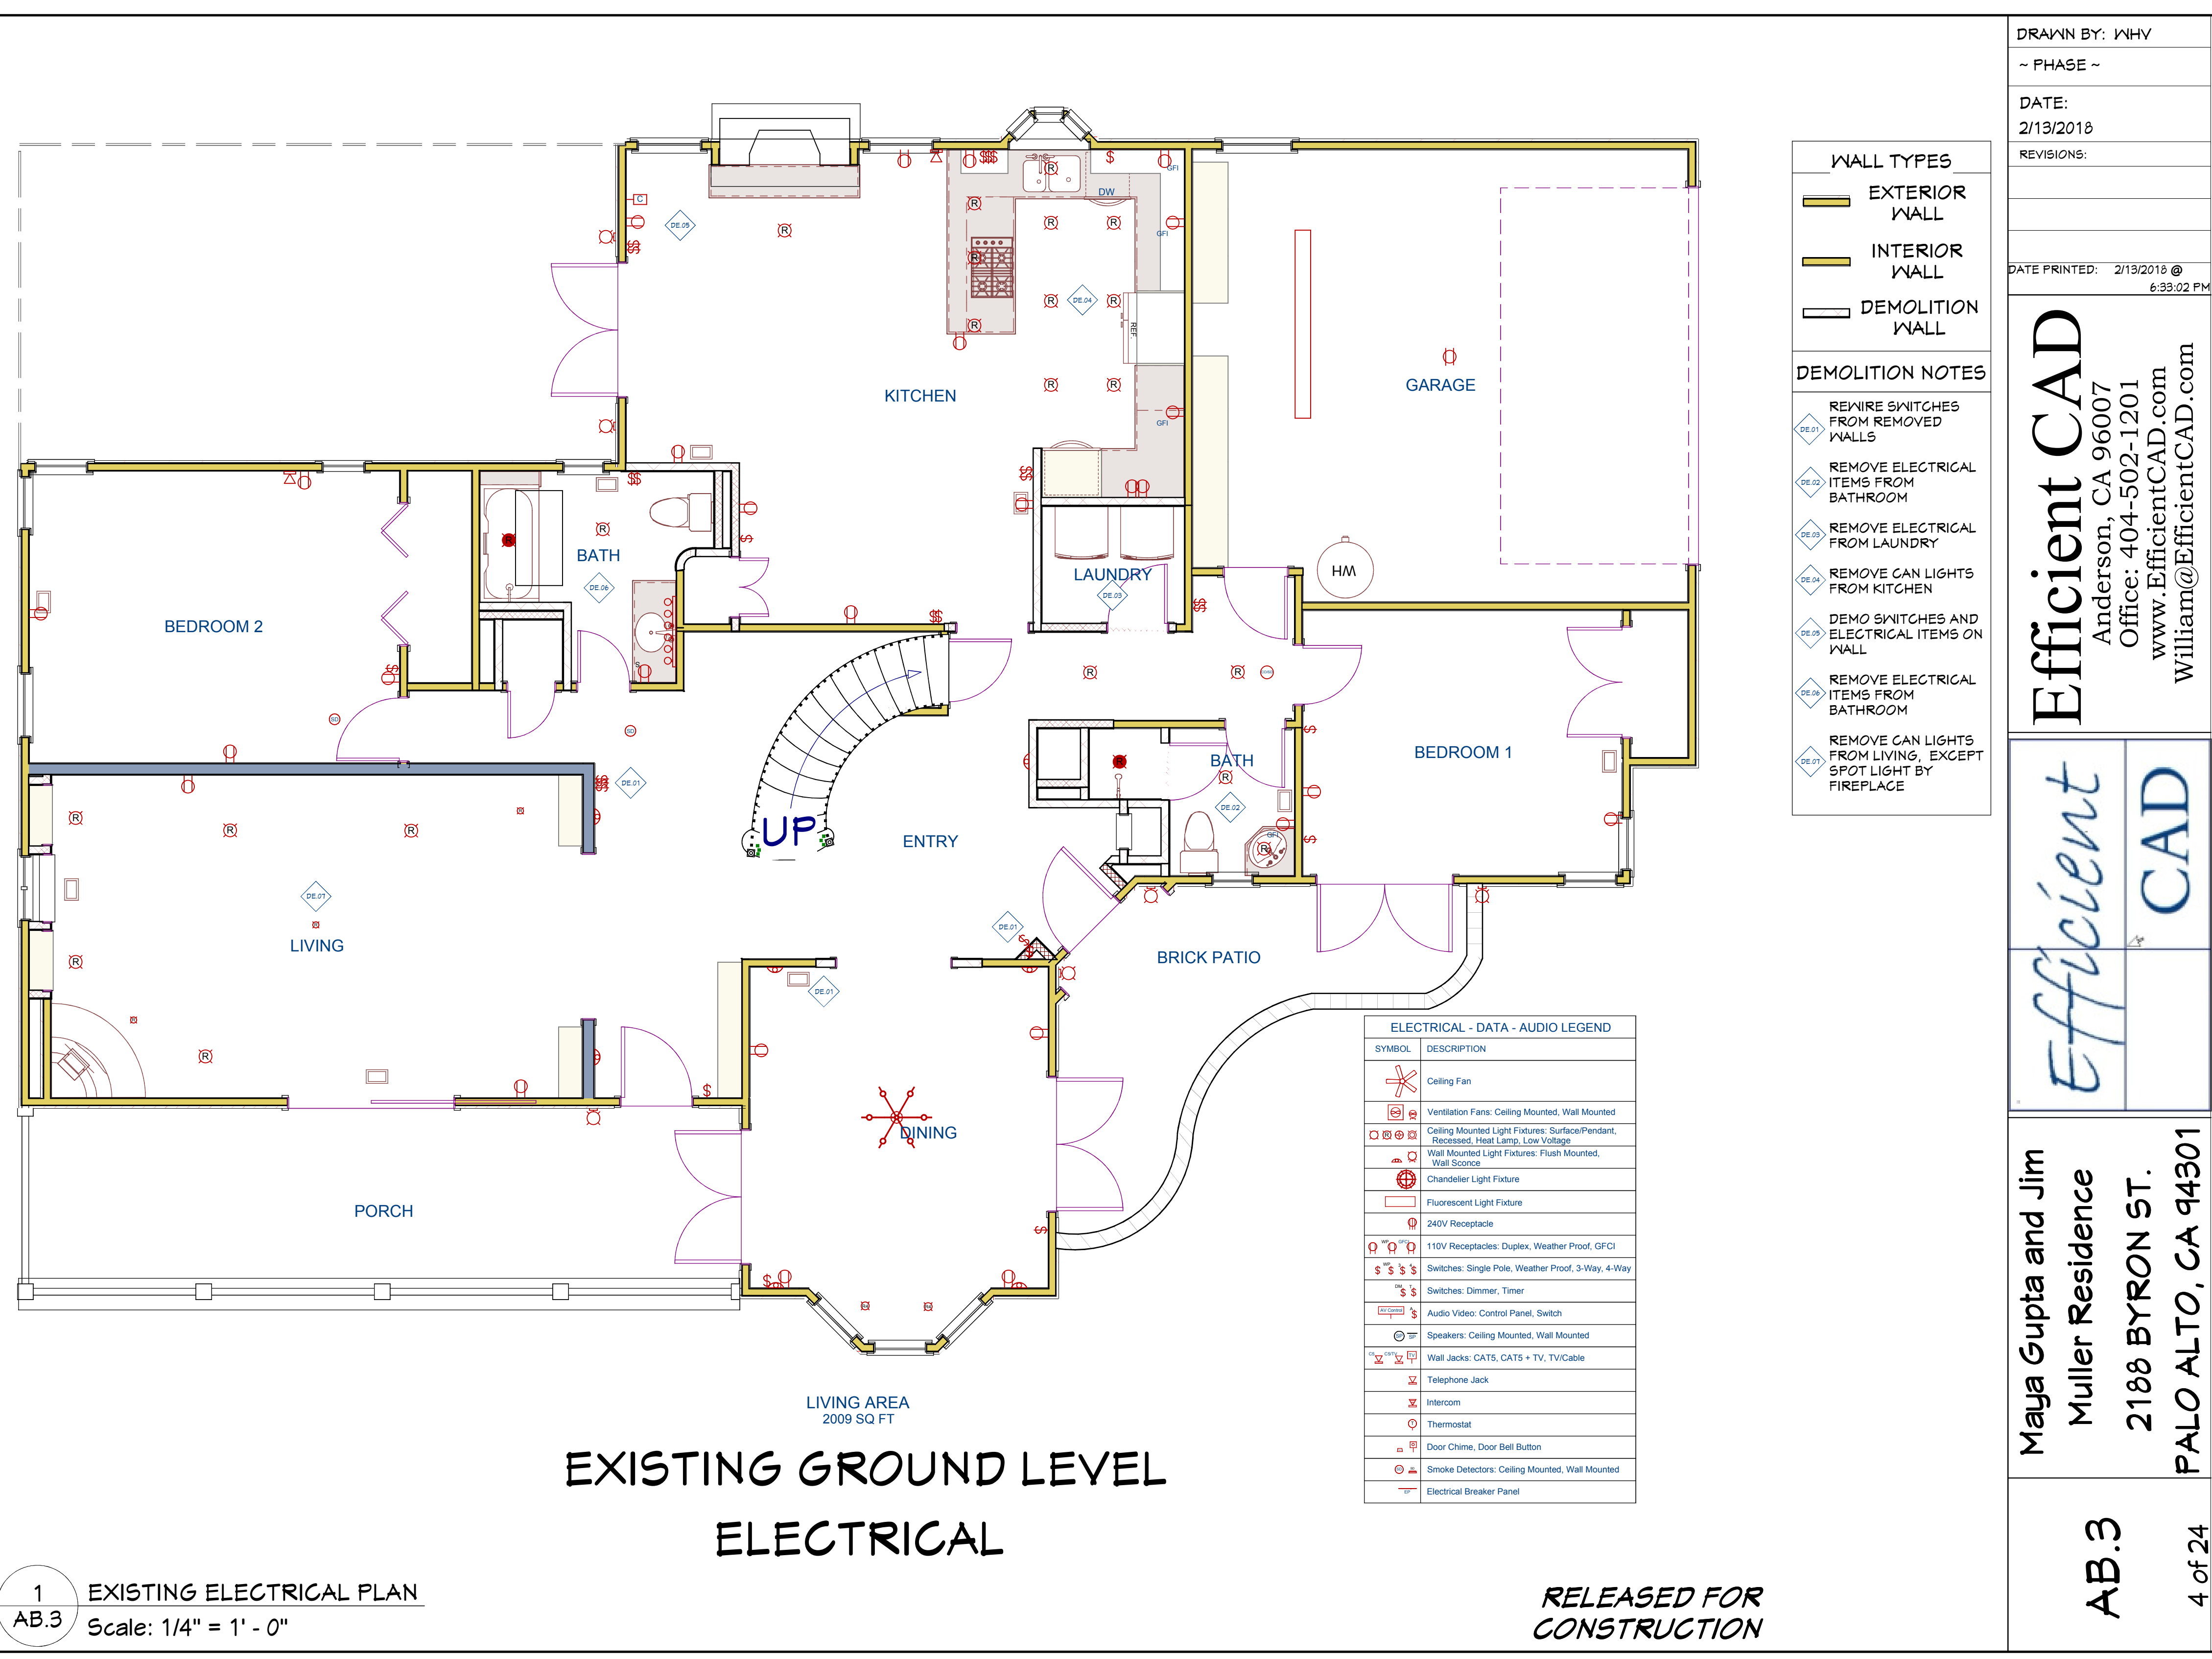

DRAWN BY: WHV
~ PHASE ~
DATE:
2/13/2018
REVISIONS:

DATE PRINTED: 2/13/2018 @ 6:33:02 PM

Efficient CAD
Anderson, CA 96007
Office: 404-502-1201
www.EfficientCAD.com
William@EfficientCAD.com

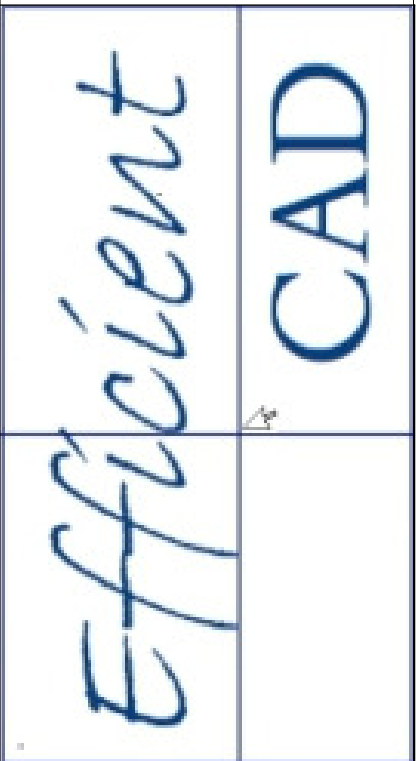


Maya Gupta and Jim
Muller Residence
2188 BYRON ST.
PALO ALTO, CA 94301

AB.3
4 of 24

- WALL TYPES**
- EXTERIOR WALL
 - INTERIOR WALL
 - DEMOLITION WALL
- DEMOLITION NOTES**
- DE.01 REWIRE SWITCHES FROM REMOVED WALLS
 - DE.02 REMOVE ELECTRICAL ITEMS FROM BATHROOM
 - DE.03 REMOVE ELECTRICAL FROM LAUNDRY
 - DE.04 REMOVE CAN LIGHTS FROM KITCHEN
 - DE.05 DEMO SWITCHES AND ELECTRICAL ITEMS ON WALL
 - DE.06 REMOVE ELECTRICAL ITEMS FROM BATHROOM
 - DE.07 REMOVE CAN LIGHTS FROM LIVING, EXCEPT SPOT LIGHT BY FIREPLACE

ELECTRICAL - DATA - AUDIO LEGEND	
SYMBOL	DESCRIPTION
	Ceiling Fan
	Ventilation Fans: Ceiling Mounted, Wall Mounted
	Ceiling Mounted Light Fixtures: Surface/Pendant, Recessed, Heat Lamp, Low Voltage
	Wall Mounted Light Fixtures: Flush Mounted, Wall Sconce
	Chandelier Light Fixture
	Fluorescent Light Fixture
	240V Receptacle
	110V Receptacles: Duplex, Weather Proof, GFCI
	Switches: Single Pole, Weather Proof, 3-Way, 4-Way
	Switches: Dimmer, Timer
	Audio Video: Control Panel, Switch
	Speakers: Ceiling Mounted, Wall Mounted
	Wall Jacks: CAT5, CAT5 + TV, TV/Cable
	Telephone Jack
	Intercom
	Thermostat
	Door Chime, Door Bell Button
	Smoke Detectors: Ceiling Mounted, Wall Mounted
	Electrical Breaker Panel

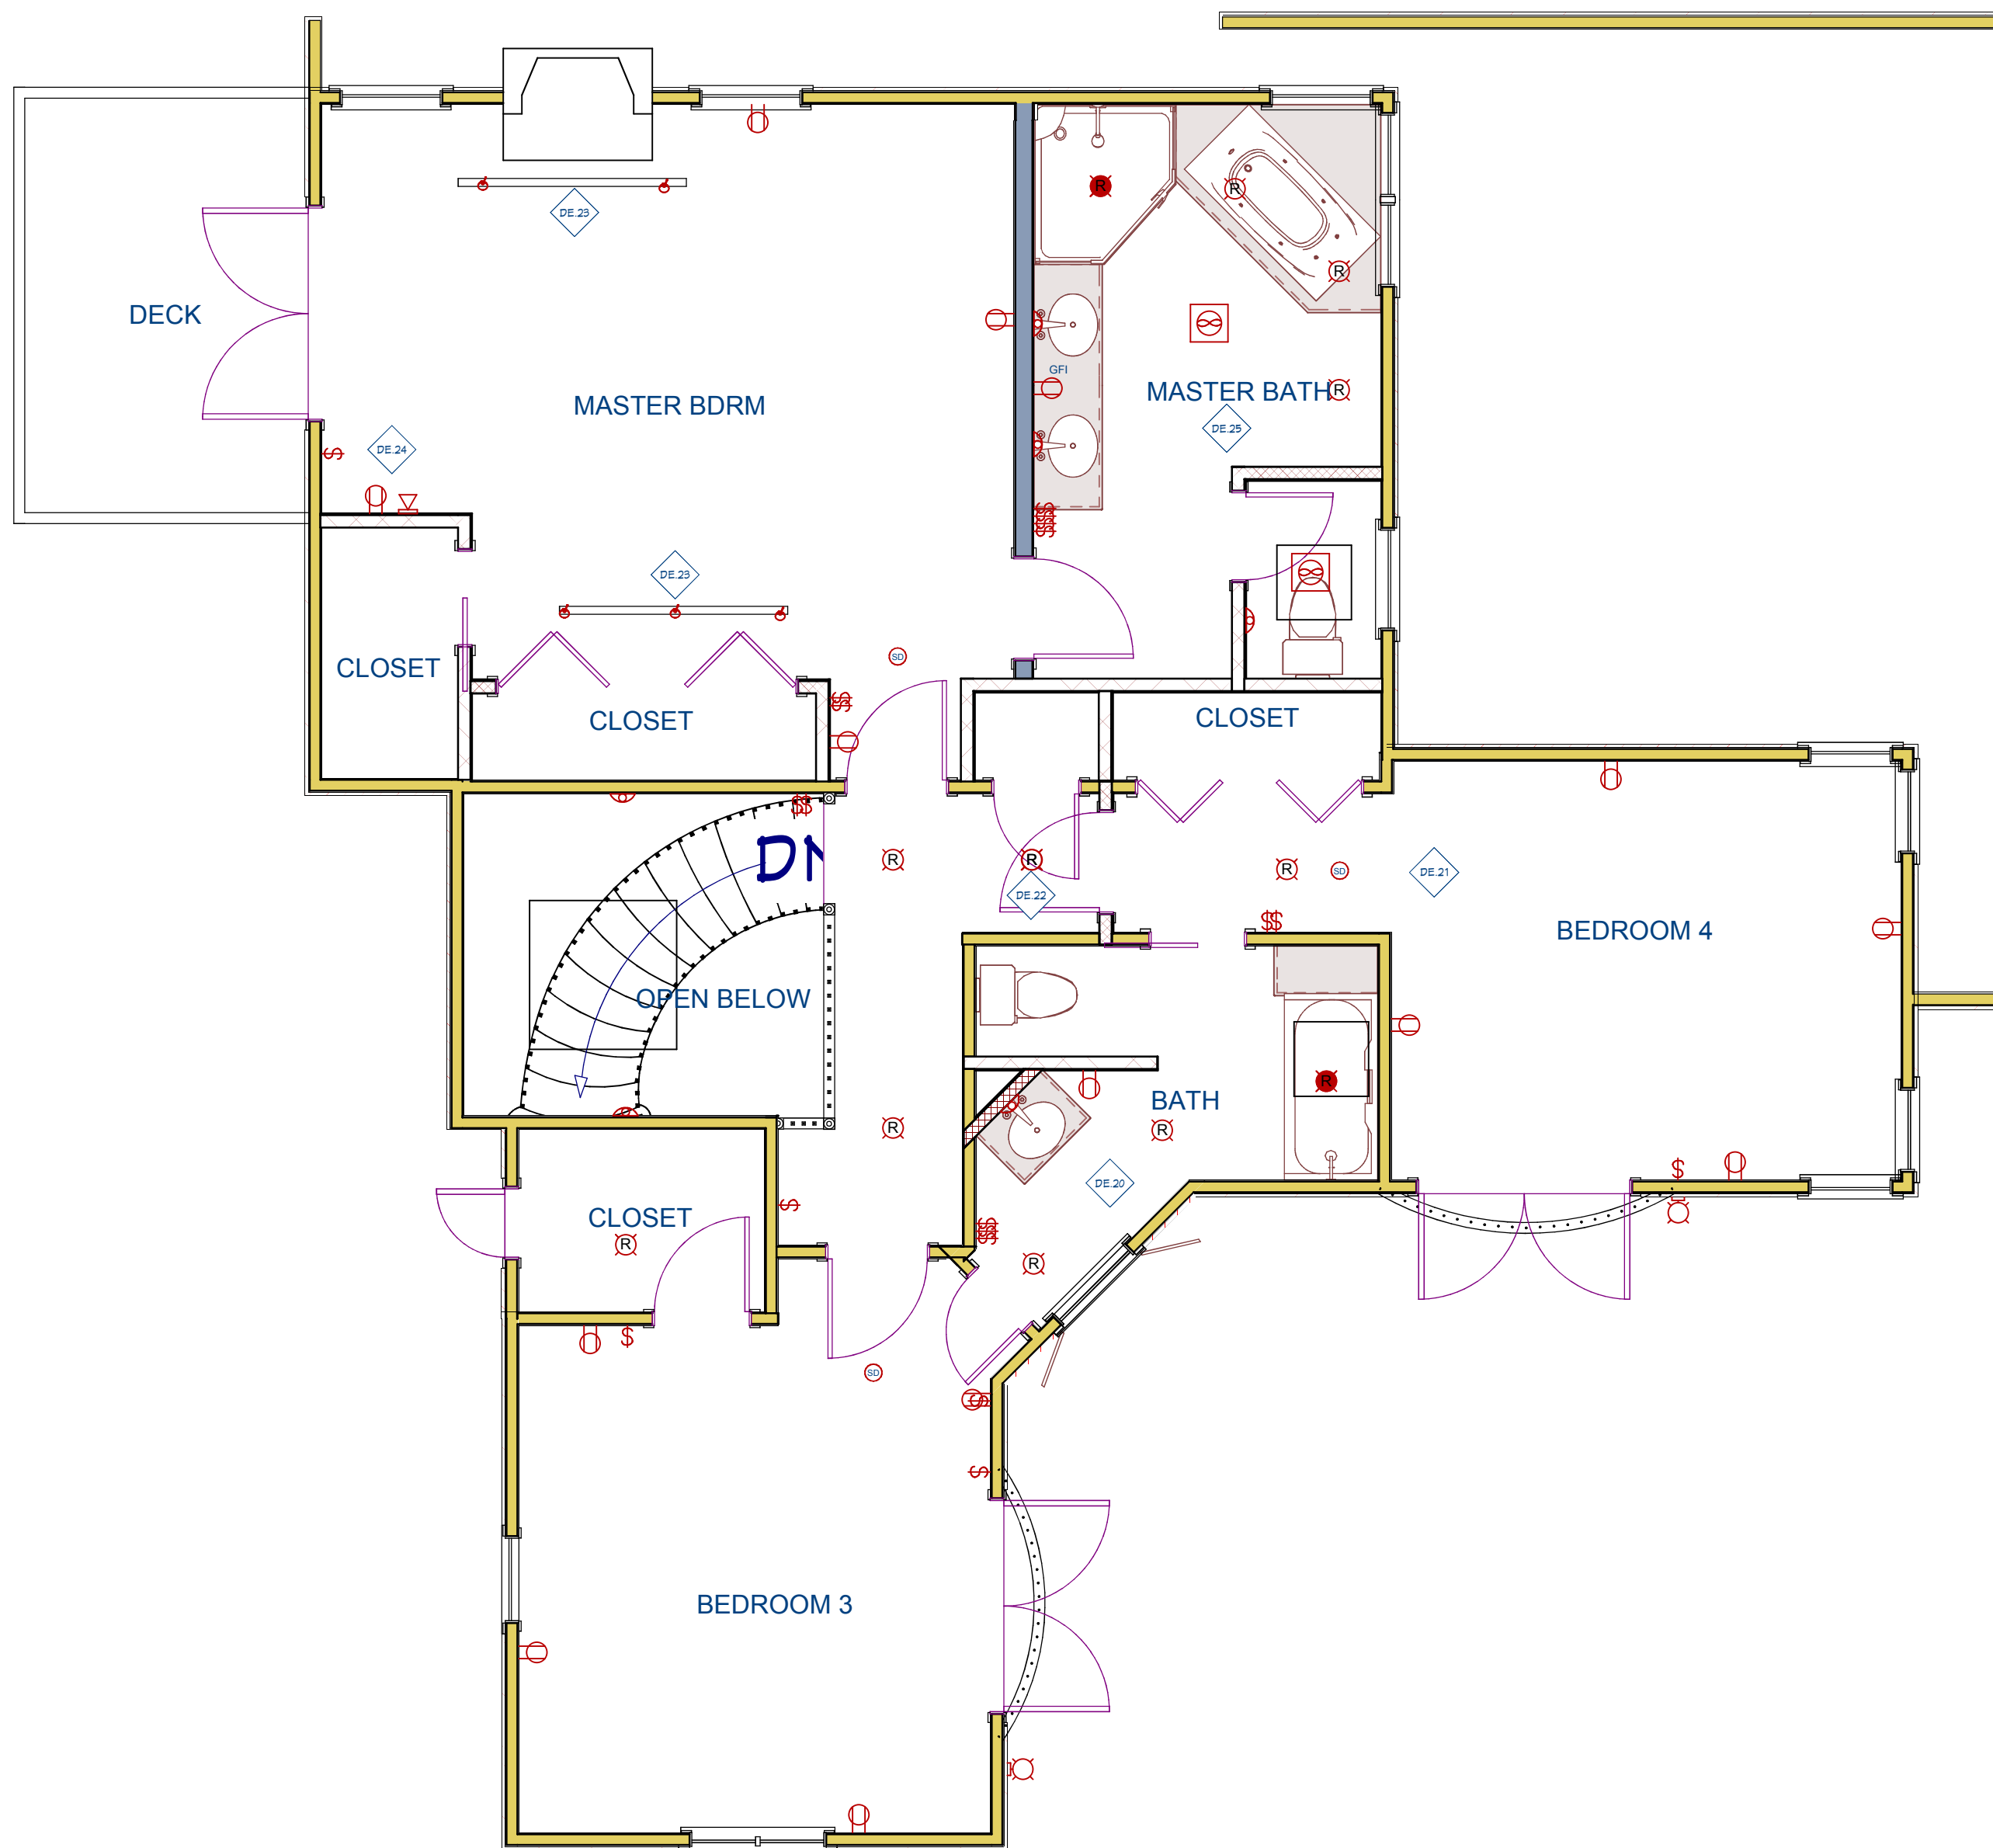


EXISTING UPPER LEVEL ELECTRICAL

WALL TYPES	
	EXTERIOR WALL
	INTERIOR WALL
	DEMOLITION WALL
DEMOLITION NOTES	
	REMOVE ALL ELECTRICAL OUTLETS AND FIXTURES FROM BATHROOM
	RELOCATE SMOKE DETECTOR
	REMOVE CAN LIGHT
	REMOVE TRACK LIGHT
	REMOVE ELECTRICAL ITEMS FROM DEMO WALLS
	REMOVE ELECTRICAL ITEMS FROM MASTER BATHROOM

DRAWN BY: WHV
~ PHASE ~
DATE: 2/13/2018
REVISIONS:
DATE PRINTED: 2/13/2018 @ 6:33:03 PM

Efficient CAD
Anderson, CA 96007
Office: 404-502-1201
www.EfficientCAD.com
William@EfficientCAD.com

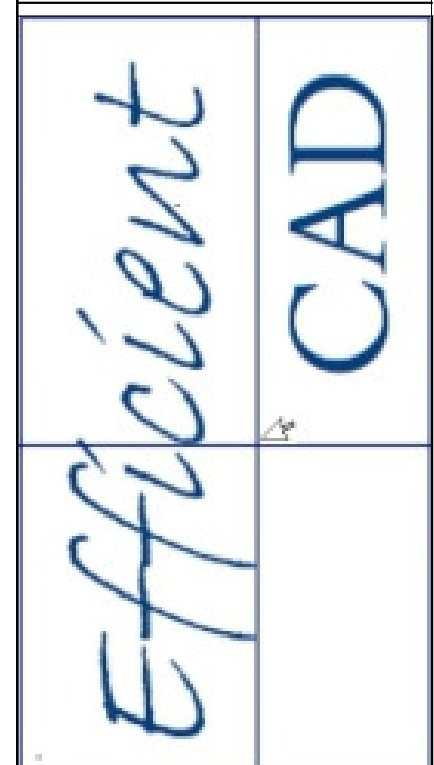


Maya Gupta and Jim
Muller Residence
2188 BYRON ST.
PALO ALTO, CA 94301

AB.4
5 of 24



EXISTING FRONT

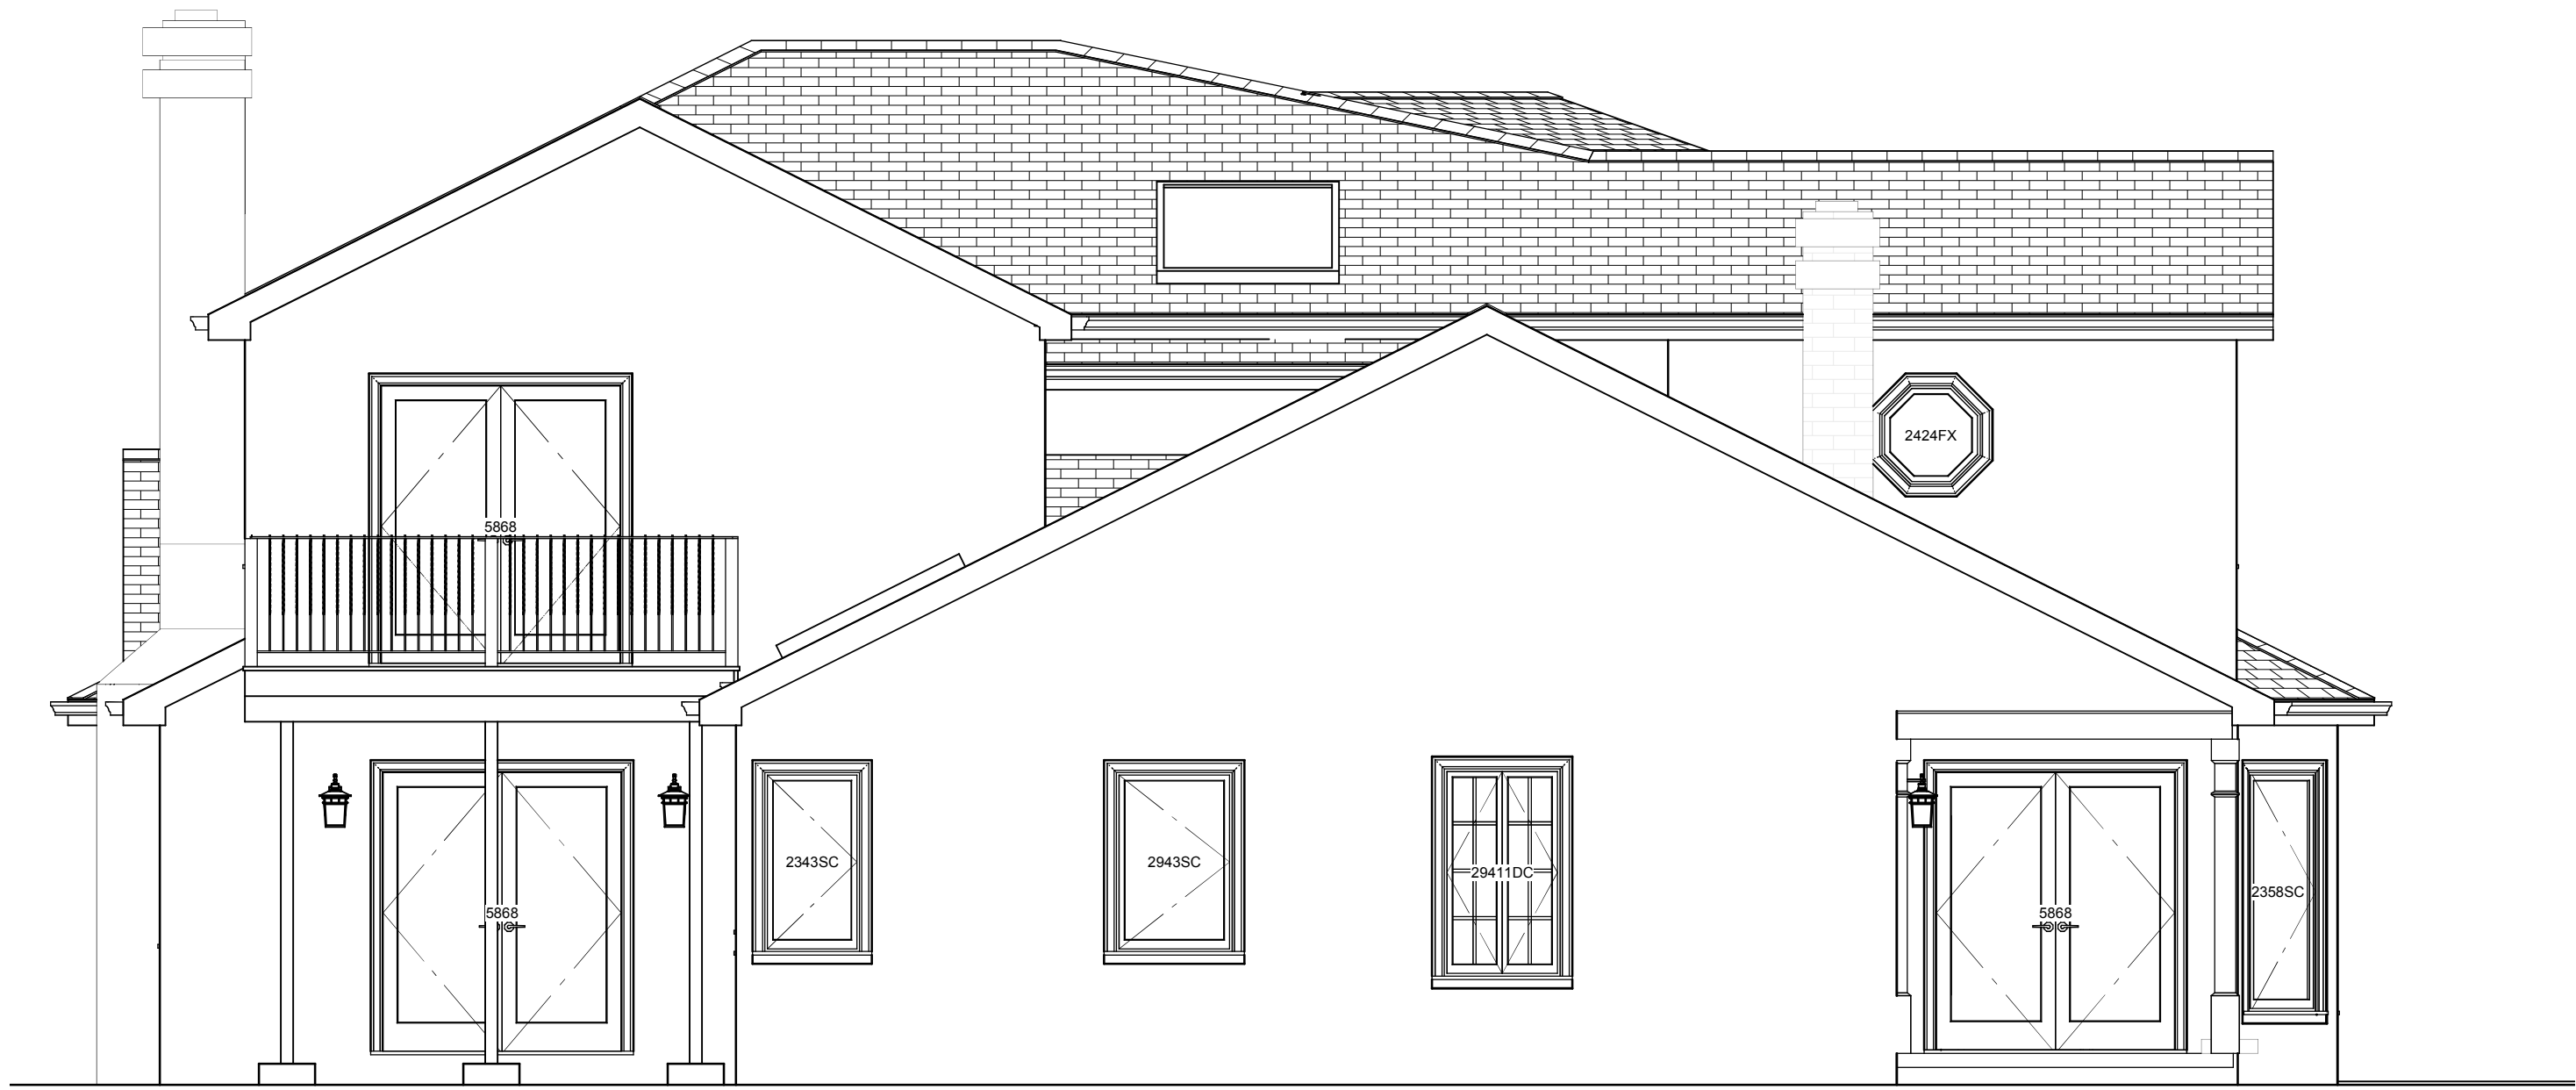

EXISTING LEFT

DRAWN BY: WHV

~ PHASE ~

DATE:
2/13/2018

REVISIONS:

DATE PRINTED: 2/13/2018 @
6:33:03 PM

Efficient CAD
Anderson, CA 96007
Office: 404-502-1201
www.EfficientCAD.com
William@EfficientCAD.com

Efficient
CAD

Maya Gupta and Jim
Muller Residence
2188 BYRON ST.
PALO ALTO, CA 94301

AB.5

6 of 24



EXISTING REAR



EXISTING RIGHT

DRAWN BY: WHV

~ PHASE ~

DATE:
2/13/2018

REVISIONS:

DATE PRINTED: 2/13/2018 @
6:33:04 PM

Efficient CAD
Anderson, CA 96007
Office: 404-502-1201
www.EfficientCAD.com
William@EfficientCAD.com

Efficient

CAD

Maya Gupta and Jim
Muller Residence
2188 BYRON ST.
PALO ALTO, CA 94301

AB.6

7 of 24

1
AB.6

EXISTING ELEVATIONS

Scale: 1/4" = 1' - 0"

**RELEASED FOR
CONSTRUCTION**



1
AB7



2
AB7

1
AB.7

EXISTING CROSS SECTION
Scale: 1/4" = 1' - 0"

RELEASED FOR
CONSTRUCTION

DRAWN BY: WHV

~ PHASE ~

DATE:
2/13/2018

REVISIONS:

DATE PRINTED: 2/13/2018 @
6:33:04 PM

Efficient CAD
Anderson, CA 96007
Office: 404-502-1201
www.EfficientCAD.com
William@EfficientCAD.com

Efficient

CAD

Maya Gupta and Jim
Muller Residence
2188 BYRON ST.
PALO ALTO, CA 94301

AB7

8 of 24

WINDOW SCHEDULE						
NUMBER	LABEL	QTY	WIDTH	HEIGHT	BOTTOM	EGRESS
W01	16410SC	4	18 "	58 "	22"	
W02	1934SC	1	21 "	40 "	40"	
W03	2342SC	2	27 "	50 "	30"	
W04	3040SC	1	36 "	48 "	32"	
W05	1333SC	3	15 "	39 "	9"	
W06	3050SC	1	36 "	60 "	20"	YES
W07	40410FX	2	48 "	58 "	22"	
W08	5013SC	1	60 "	15 "	65"	
W09	5850DC	1	68 "	60 "	20"	
W10	29413C	2	33 "	49 "	31"	
W11	110110FX	1	22 "	22 "	58"	
W12	2350SC	2	27 "	60 "	20"	
W13	2350FX	1	27 "	60 "	20"	

ALL WINDOW SIZES TO BE FIELD VERIFIED. REPLACE IN EXISTING OPENING WHERE POSSIBLE.

3'-7"
2'-7"

W06

W11 1.04

1.04 W08 1.27

U242794R

W06624 1.26 1.19

12'-5"

15'-4"

BEDROOM 2
195 SQ FT

1'-6"

2'-8"

6'-0"

9"

1.16

1.18

1.17

D16

1.15

BATH
37 SQ FT

1.14

1.13

D08

4'-5"

DB1221/SB1214/DB121

3'-1"

2888

U361290

7'-0"

2'-0"

3DB0118 1.26 1.19

13'-9"

LIVING
315 SQ FT

22'-7"

12'

6'-4"

1'-1"

4'-3"

3'-4"

U361290

7065


D03 1.04 1.33

**VERIFY STRUCTURAL INTEGRITY
OF WALL AND FOUNDATION
BELOW FOR ROOF LOAD**

PORCH
226 SQ FT

1.34

DOOR SCHEDULE							
NUMBER	LABEL	QTY	SIZE	WIDTH	HEIGHT	DESCRIPTION	COMMENTS
D01	10068	1	10068 L EX	120 "	80 "	EXT. TRIPLE SLIDER-GLASS	
D02	5468	1	5468 L/R EX	69 "	80 "	EXT. DOUBLE HINGED-GLASS	
D03	12068	1	12068 L/R EX	144 "	80 "	EXT. QUAD SLIDER-GLASS	
D04	1668	1	1668 R IN	18 "	80 "	HINGED-DOOR P09	
D05	16080	1	16080	192 "	96 "	GARAGE-GARAGE DOOR CHD09	
D06	5868	1	5868 L/R EX	67 7/8 "	80 "	EXT. DOUBLE HINGED-GLASS	
D07	2668	1	2668 L	30 "	80 "	POCKET-DOOR P09	
D08	2668	3	2668 L IN	30 "	80 "	HINGED-DOOR P09	
D16	4868	1	4868 L IN	56 "	80 "	SLIDER-GLASS DOOR SC02	SHOWER DR.

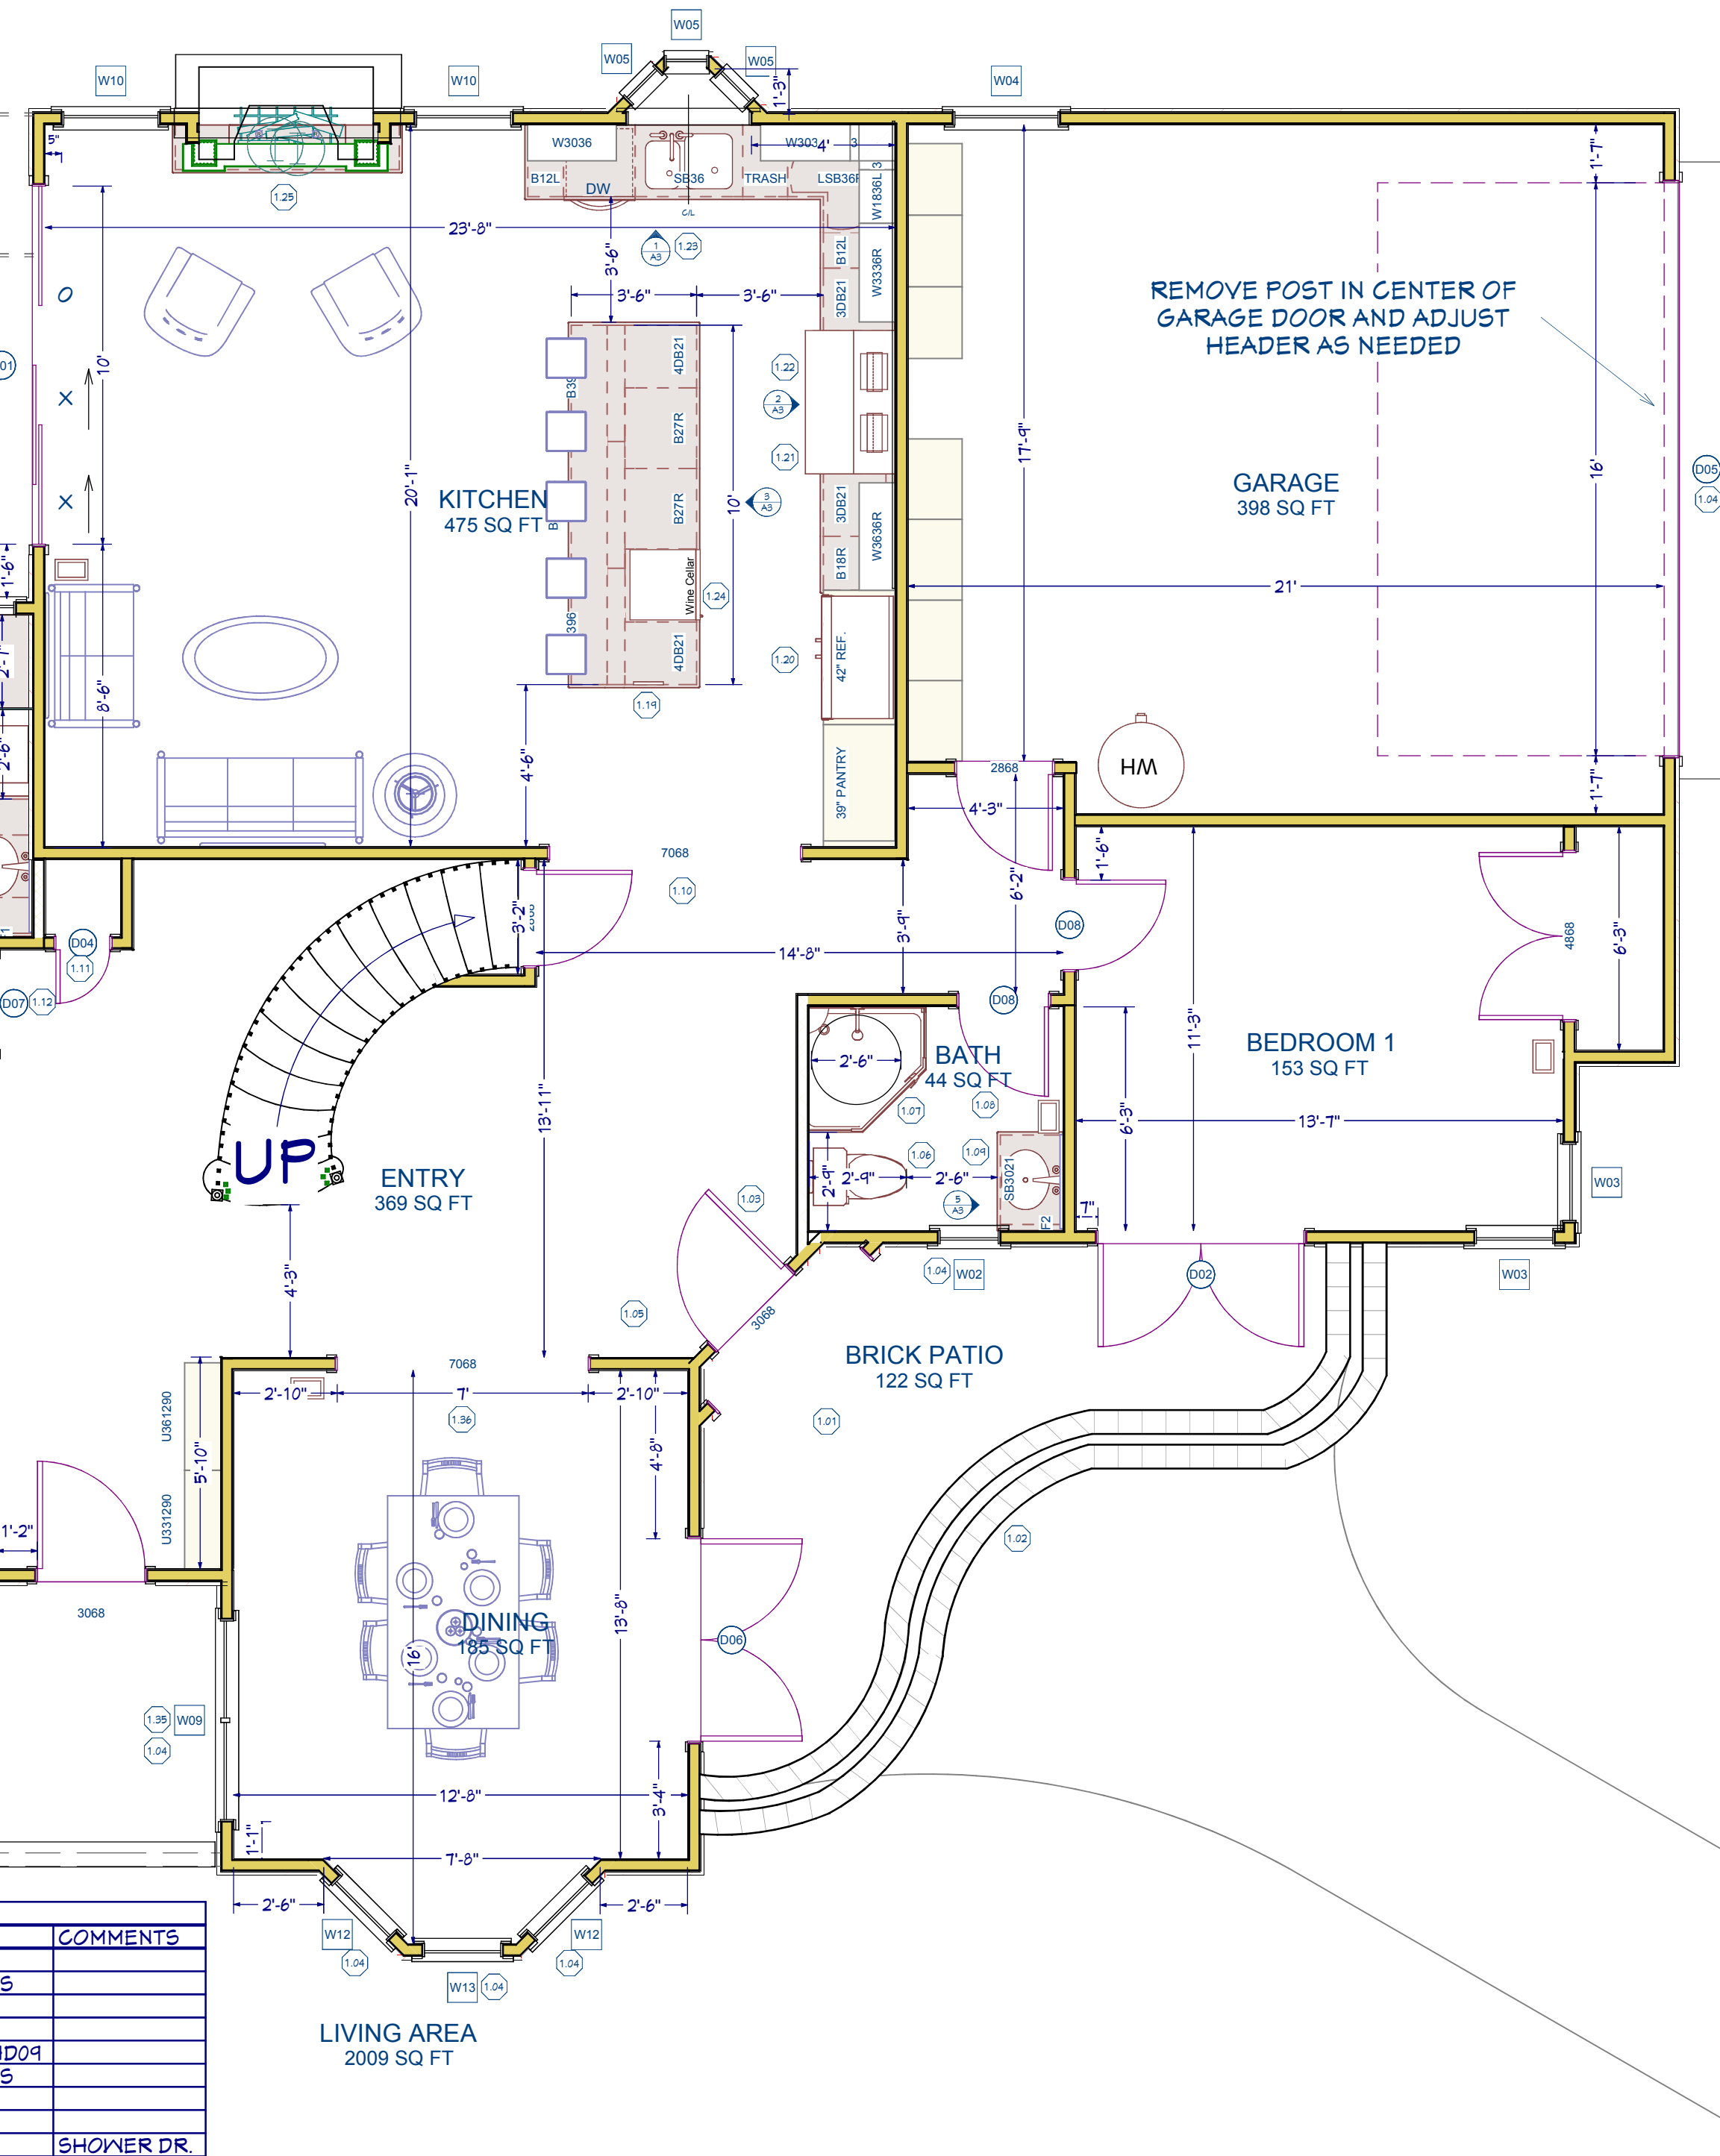

 EXTERIOR WALL
 INTERIOR WALL
 NEW WALL

- 1.01 RAISE PATIO TO BE 1" BELOW LEVEL OF EXISTING HOUSE
- 1.02 BUILD BRICK STEP FOR NEW RAISED PATIO LEVEL
- 1.03 REDIRECT PLUMBING CHASE FROM BATHROOM ABOVE
- 1.04 CHANGE HEADER AS NEEDED AND PATCH STUCCO
- 1.05 PATCH HARDWOOD FLOORS WHERE WALLS HAVE BEEN REMOVED OR DOORWAYS WIDENED

- 1.06 INSTALL NEW TOILET
- 1.07 NEW 42" ANGLED SHOWER
- 1.08 NEW TILE FLOOR
- 1.09 NEW 30" VANITY
- 1.10 WIDEN DOORWAY TO 84"
- 1.11 NEW 18" DOOR FOR NEW CLOSET
- 1.12 NEW 30" POCKET DOOR
- 1.13 NEW 30" DOOR
- 1.14 NEW VANITY
- 1.15 REPLACE ALL WOOD FLOOR VENTS
- 1.16 MOVE FLOOR VENT
- 1.17 TILED SHOWER BENCH
- 1.18 NEW SHOWER W. TILE TO CEILING
- 1.19 RELOCATE FLOOR VENT TO TOE KICK OF CABINET

- 1.20 BUILT-IN 42" REFRIGERATOR
- 1.21 48" HOOD VENTED TO EXTERIOR
- 1.22 48" GAS RANGE
- 1.23 NEW SINK IN EXISTING LOCATION
- 1.24 NEW WINE COOLER
- 1.25 NEW FIREPLACE INSERT USING EXISTING CHIMNEY
- 1.26 NEW TRIPLE 10' WIDE X 68" SLIDING DOORS
- 1.27 NEW 60" X 15" TRANSLUM. CLEAR GLASS
- 1.28 NEW BENCH SEAT
- 1.29 NEW TRIPLE CASEMENT WINDOW
- 1.30 HEIGHT AND HEADER TO MATCH EXISTING CORNER CASEMENTS

DATE PRINTED: 2/13/2018 @ 6:33:05 PM

fficient CAD
Anderson, CA 96007
Office: 404-502-1201
www.EfficientCAD.com
William@EfficientCAD.com

Efficient	CAD
-----------	-----


Maya Gupta and Jim
Muller Residence
2188 BYRON ST.
PALO ALTO CA 94301

4

9 of 24

PROPOSED GROUND LEVEL

RELEASED FOR
CONSTRUCTION

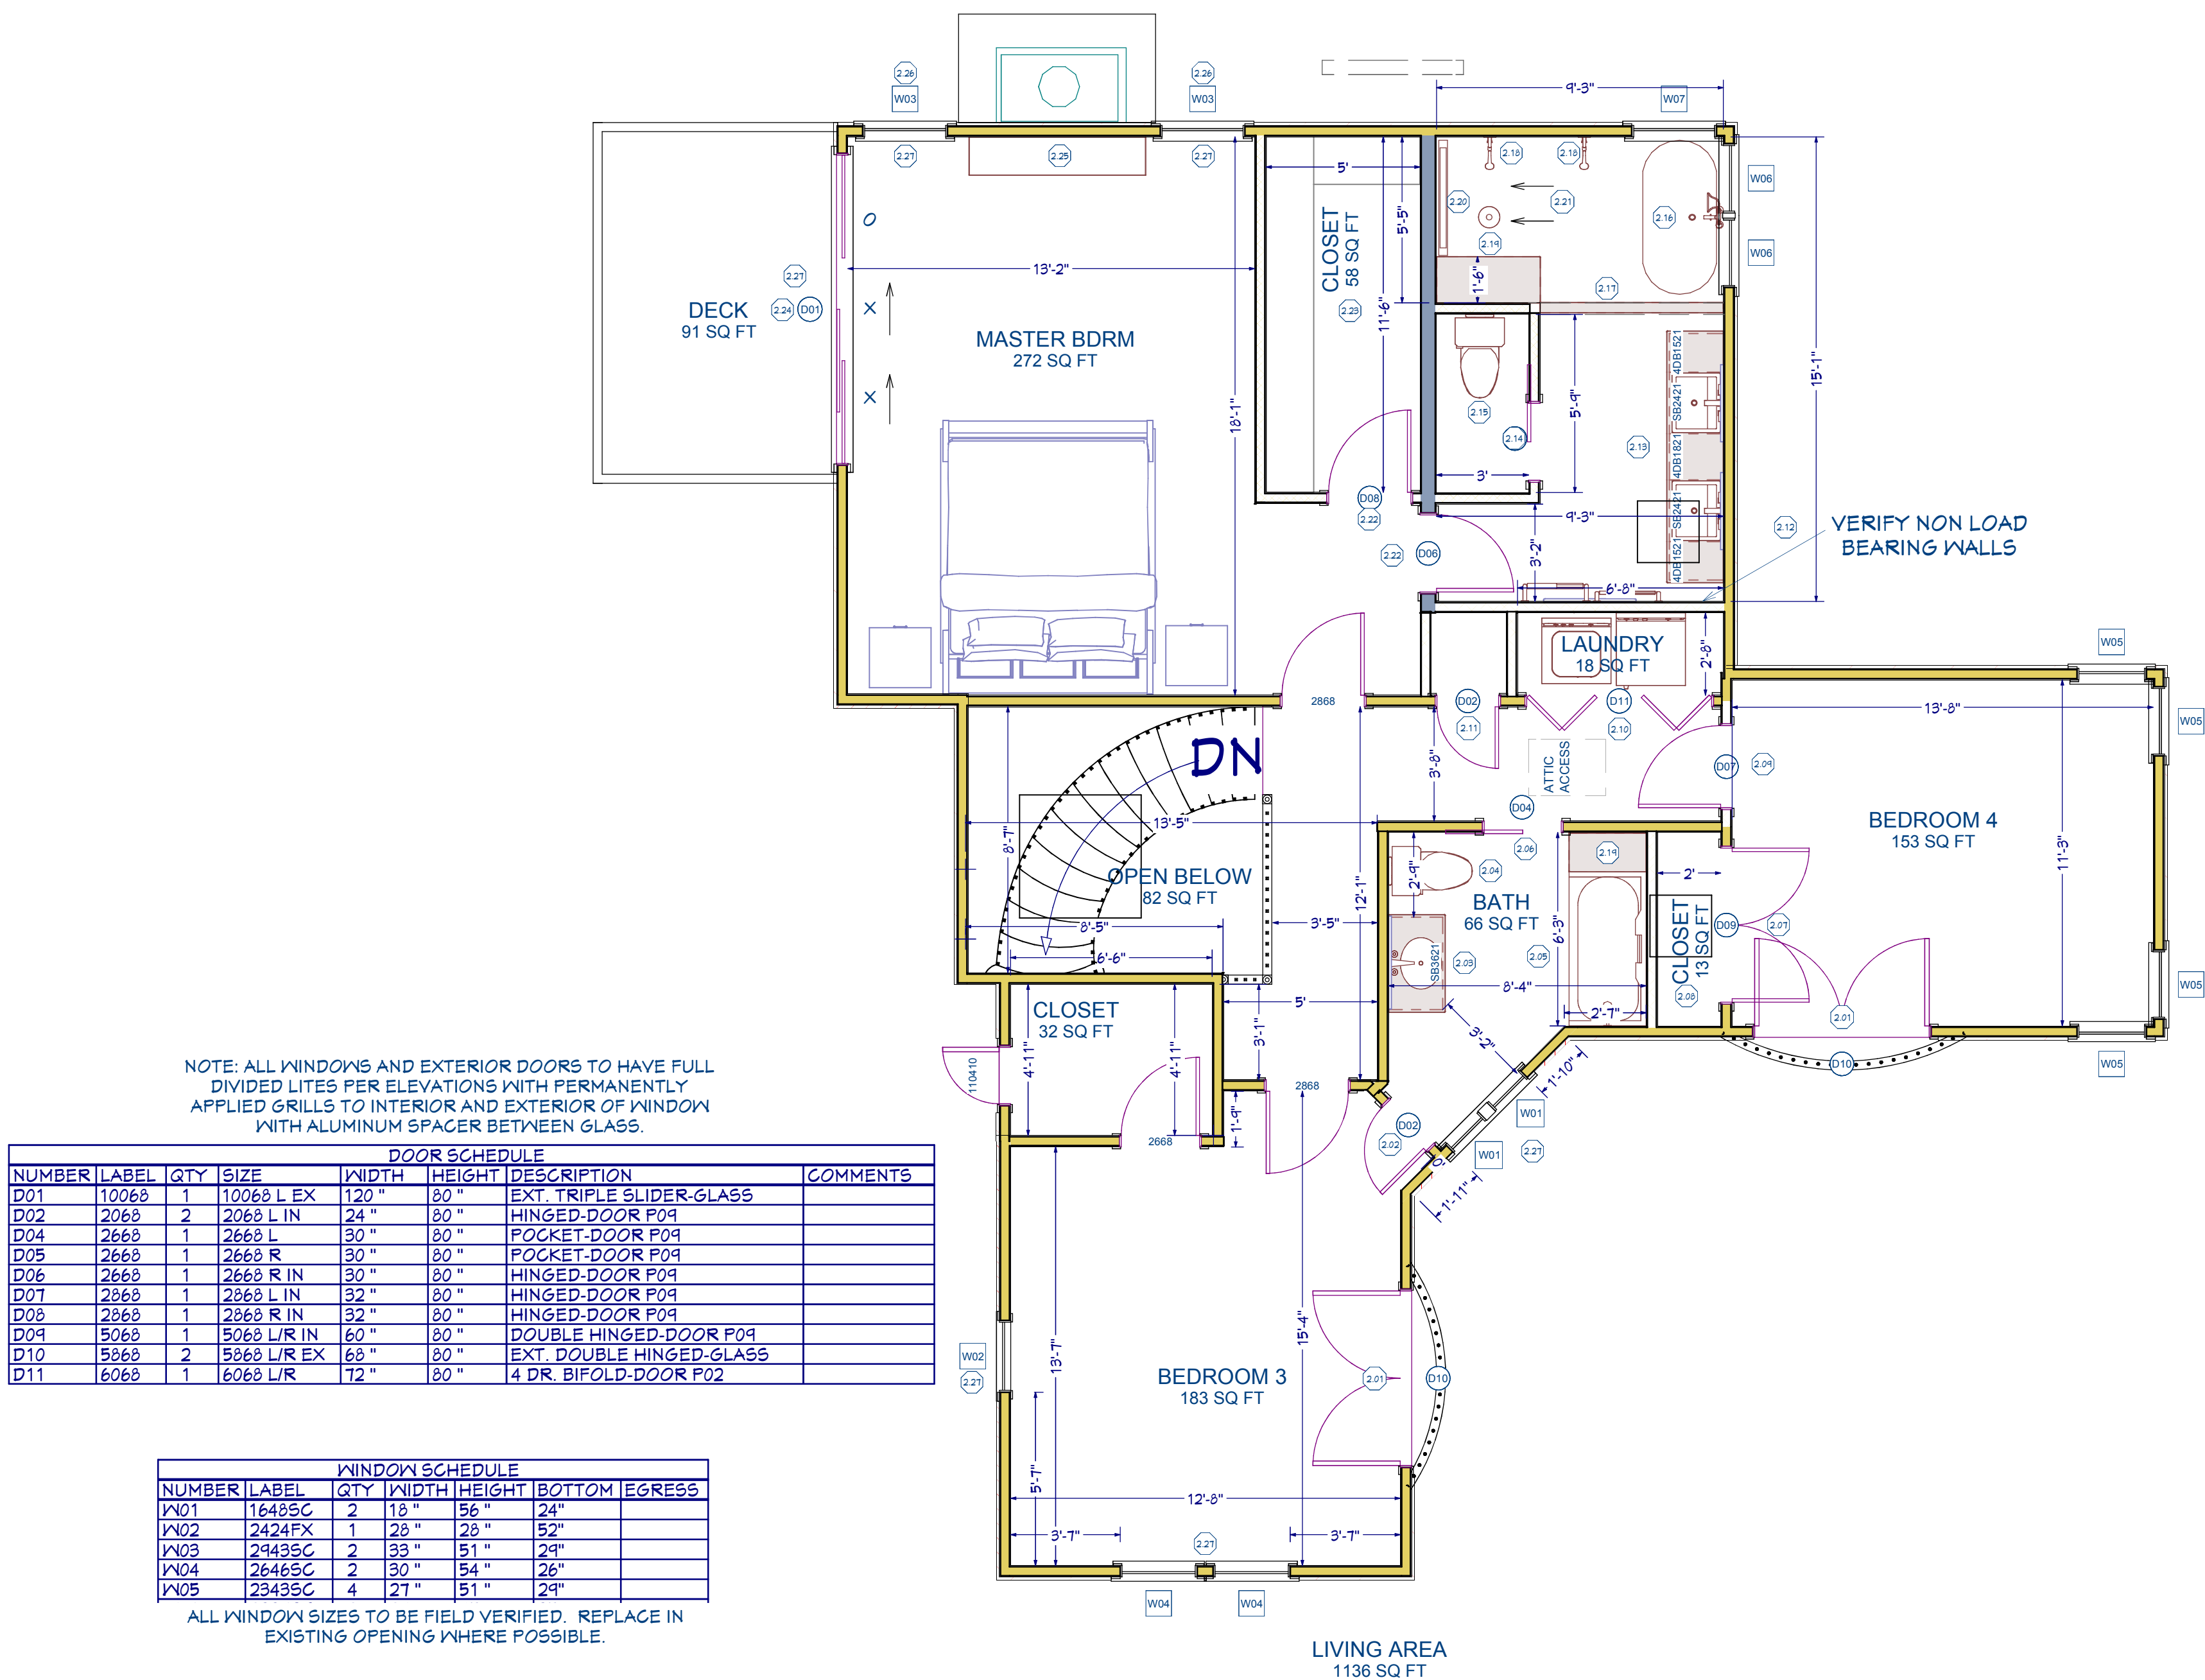

DOOR SCHEDULE						
NUMBER	LABEL	QTY	SIZE	WIDTH	HEIGHT	DESCRIPTION
D01	10068	1	10068 L EX	120"	80"	EXT. TRIPLE SLIDER-GLASS
D02	2068	2	2068 L IN	24"	80"	HINGED-DOOR P09
D04	2668	1	2668 L	30"	80"	POCKET-DOOR P09
D05	2668	1	2668 R	30"	80"	POCKET-DOOR P09
D06	2668	1	2668 R IN	30"	80"	HINGED-DOOR P09
D07	2868	1	2868 L IN	32"	80"	HINGED-DOOR P09
D08	2868	1	2868 R IN	32"	80"	HINGED-DOOR P09
D09	5068	1	5068 L/R IN	60"	80"	DOUBLE HINGED-DOOR P09
D10	5868	2	5868 L/R EX	68"	80"	EXT. DOUBLE HINGED-GLASS
D11	6068	1	6068 L/R	72"	80"	4 DR. BIFOLD-DOOR P02
COMMENTS						

WINDOW SCHEDULE						
NUMBER	LABEL	QTY	WIDTH	HEIGHT	BOTTOM	EGRESS
W01	1648SC	2	18"	56"	24"	
W02	2424FX	1	28"	28"	52"	
W03	2943SC	2	33"	51"	29"	
W04	2646SC	2	30"	54"	26"	
W05	2343SC	4	27"	51"	29"	

ALL WINDOW SIZES TO BE FIELD VERIFIED. REPLACE IN EXISTING OPENING WHERE POSSIBLE.

PROPOSED UPPER LEVEL

WALL TYPES

EXTERIOR WALL

INTERIOR WALL

NEW WALL

PLAN NOTES

1.35 WIDEN OPENING TO 64" WIDE

1.34 REPLACE FRENCH DOORS WITH NEW CASEMENTS UNDER EXISTING HEADER

1.35 REMOVE ROOF OVER PORCH

1.36 12' WIDE X 6'8" 4 PANEL SLIDER

2.01 NEW IN-SWING FRENCH DOORS

2.02 CHANGE SWING OF DOOR

2.03 NEW VANITY

2.04 REPLACE TOILET IN EXISTING LOCATION

2.05 NEW TUB WITH TILE TO CEILING

2.06 NEW 30" POCKET DOOR

2.07 60" DOUBLE CLOSET DOOR

2.08 CLOSE IN SKYLIGHT CEILING OPENING BUT KEEP SKYLIGHT IN ROOF.

2.09 NEW BEDROOM DOOR LOCATION

2.10 NEW WASHER AND DRYER LOCATION

2.11 24" CLOSET DOOR

2.12 CLOSE IN WINDOW

2.13 NEW DOUBLE VANITY

2.14 30" POCKET DOOR

2.15 NEW TOILET

2.16 FREE STANDING TUB

2.17 4" CURB

2.18 (2) HANDHELD SPRAY AND (1) RAIN HEAD

2.19 18" TALL X 18" WIDE TILED BENCH W. SLOPED SEAT

2.20 TRENCH DRAIN

2.21 TILE ON WALLS TO CEILING IN SHOWER AREA

2.22 NEW 30" DOOR

2.23 NEW WALK IN CLOSET

2.24 10' X 6'8" TRIPLE SLIDER DOOR

2.25 NEW FIREPLACE INSERT USING EXISTING CHIMNEY

2.26 REPLACE CASEMENT WINDOWS, MATCH HEIGHT OF SLIDING DOORS

2.27 REPLACE HEADER AND PATCH STUCCO

DRAWN BY: WHV

~ PHASE ~

DATE: 2/13/2018

REVISIONS:

DATE PRINTED: 2/13/2018 @ 6:33:06 PM

Efficient CAD

Anderson, CA 96007

Office: 404-502-1201

www.EfficientCAD.com

William@EfficientCAD.com

Efficient CAD

Maya Gupta and Jim Muller Residence

2188 BYRON ST.

PALO ALTO, CA 94301

A2.1

10 of 24

1

A2.1

PROPOSED PLAN

Scale: 1/4" = 1' - 0"

RELEASED FOR CONSTRUCTION



PROPOSED REAR



PROPOSED RIGHT

DRAWN BY: WHV

~ PHASE ~

DATE:
2/13/2018

REVISIONS:

DATE PRINTED: 2/13/2018 @
6:33:08 PM


Efficient CAD
Anderson, CA 96007
Office: 404-502-1201
www.EfficientCAD.com
William@EfficientCAD.com

Efficient
CAD


Maya Gupta and Jim
Muller Residence
2188 BYRON ST.
PALO ALTO, CA 94301

A4.1


12 of 24

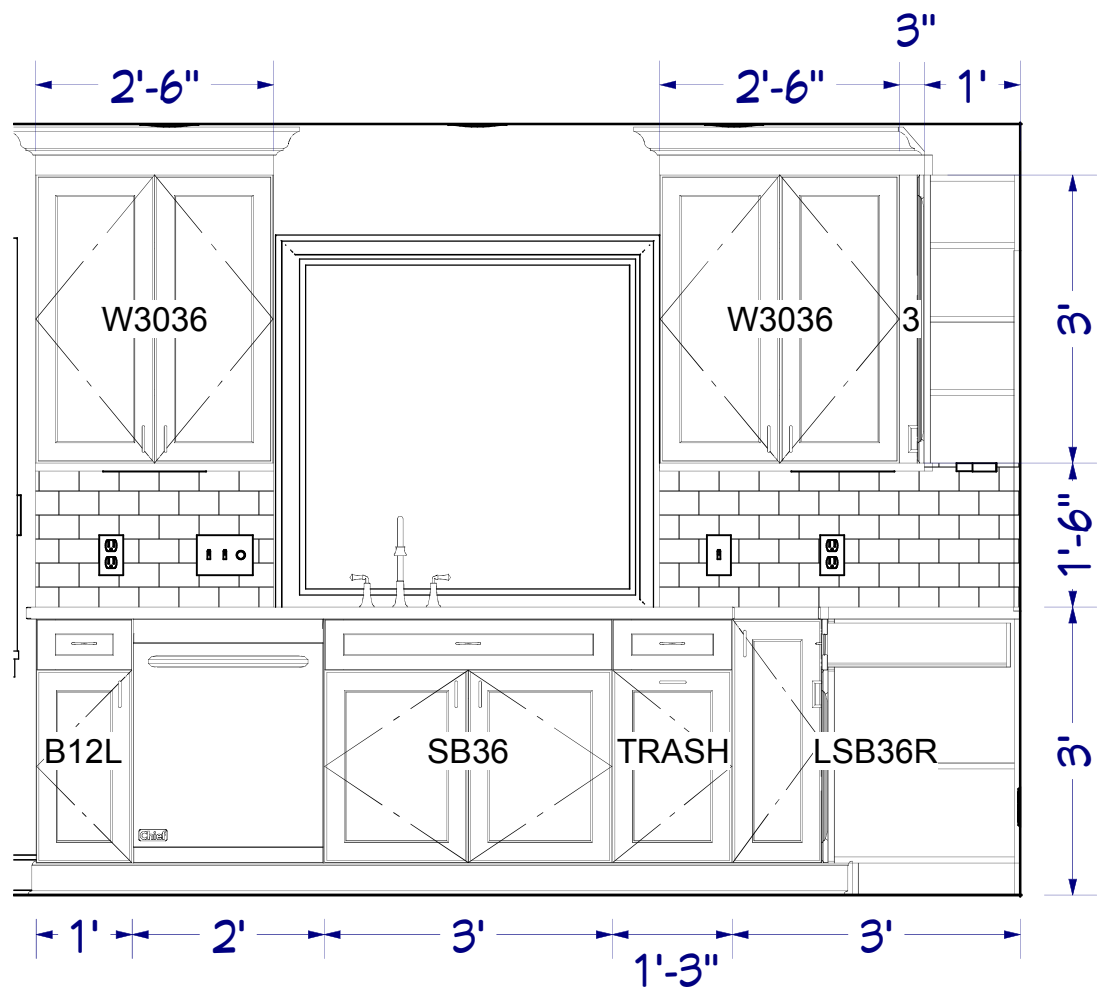


1
A3

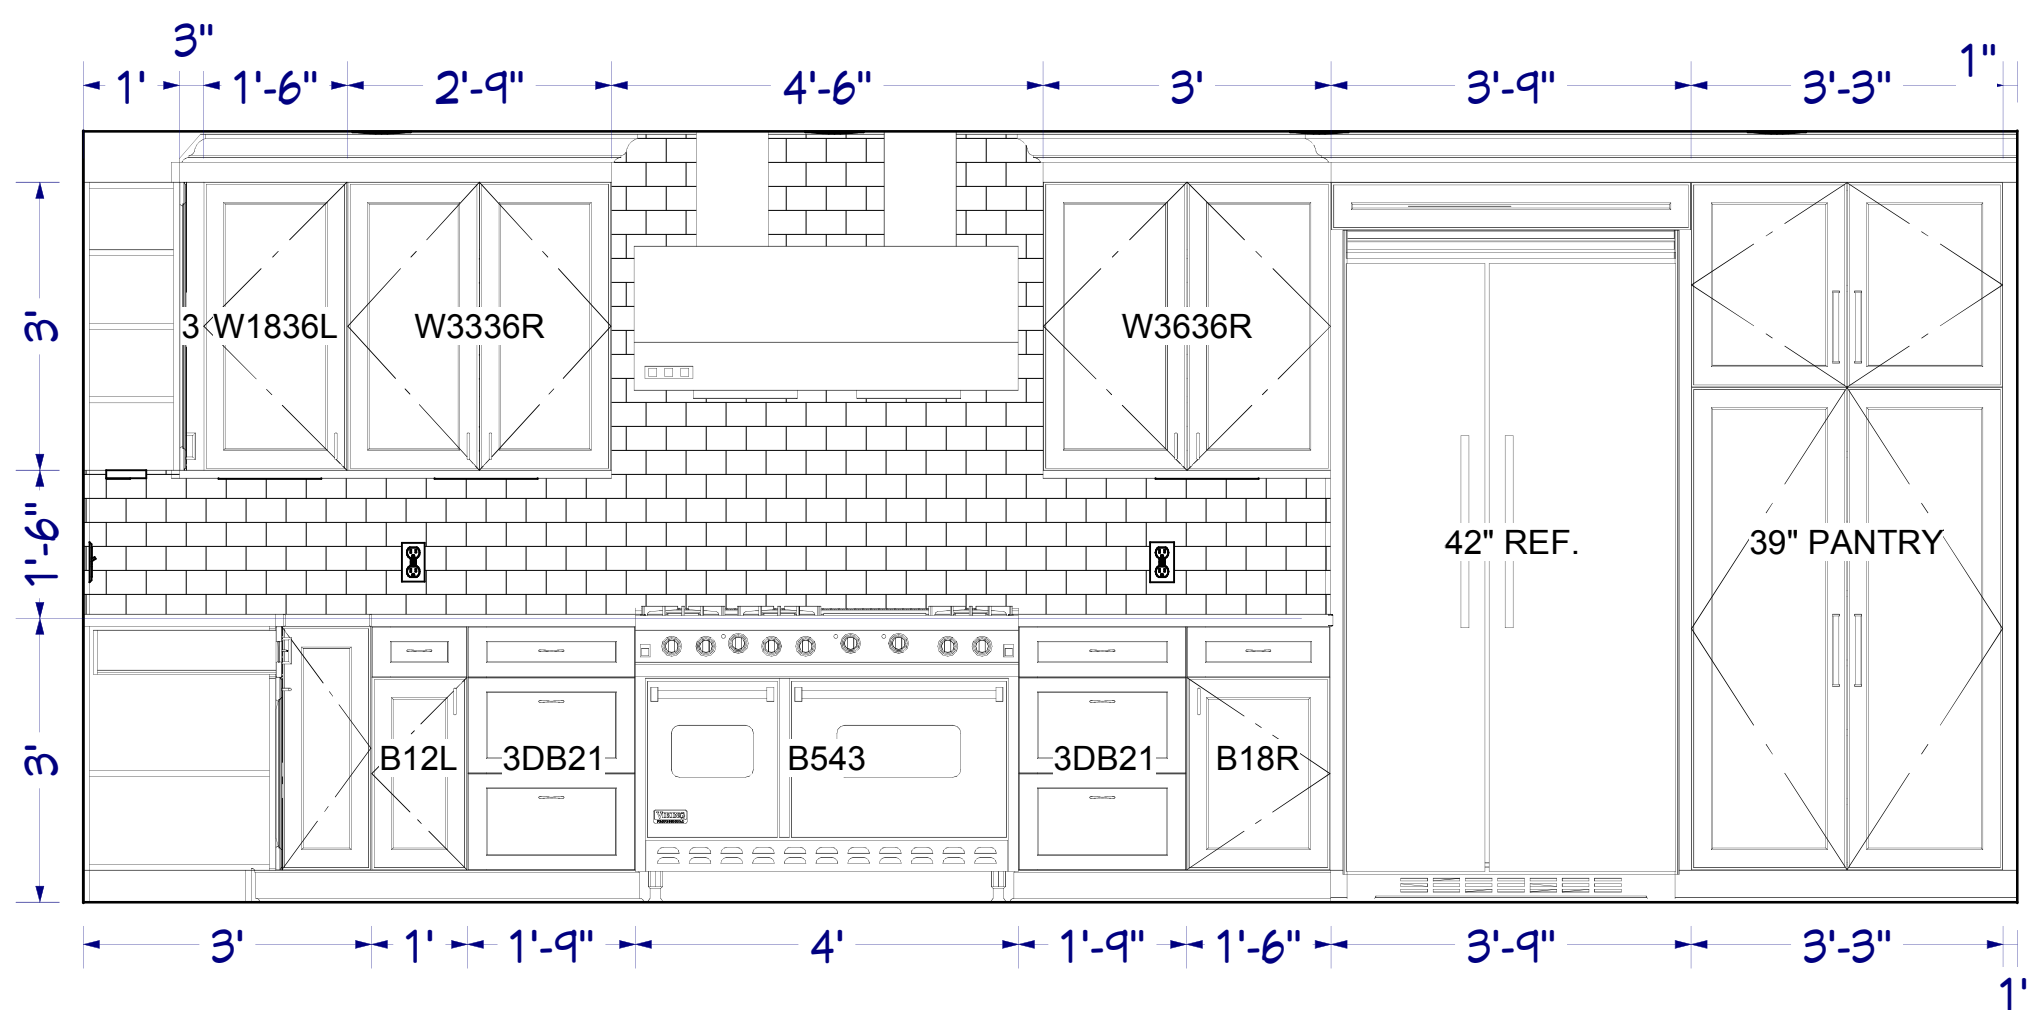


2
A3

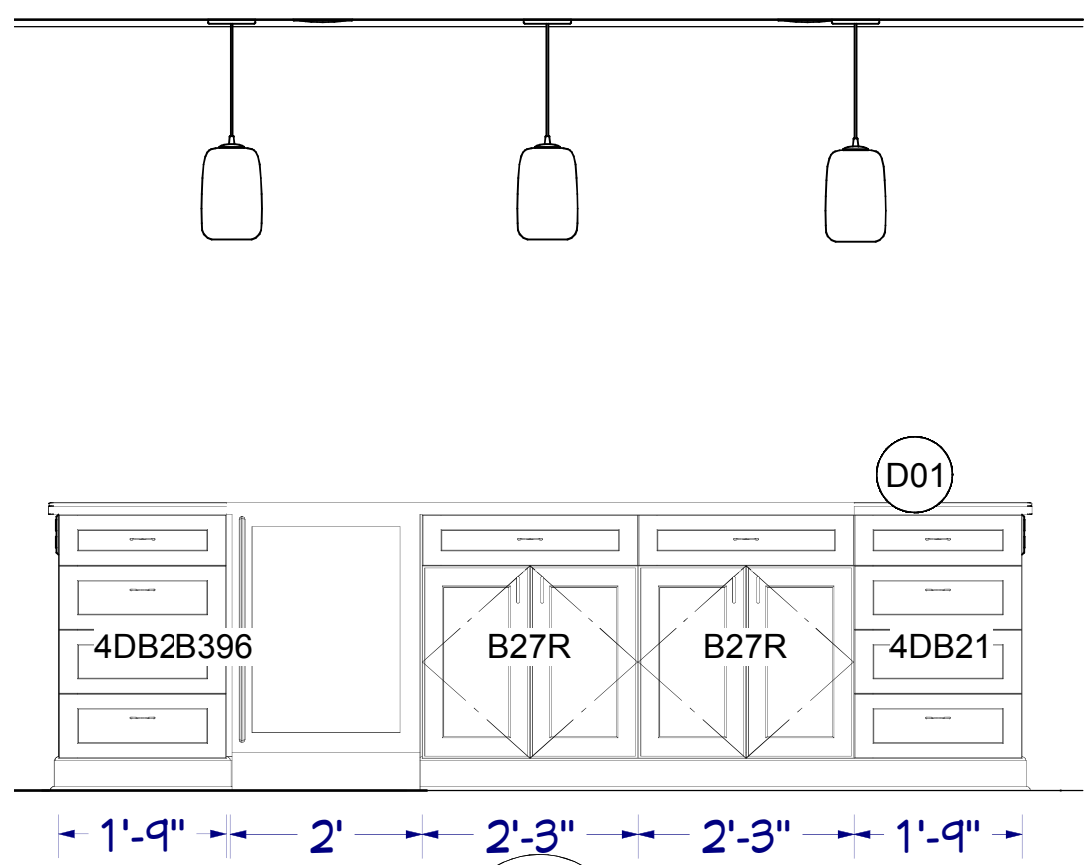


3
A3

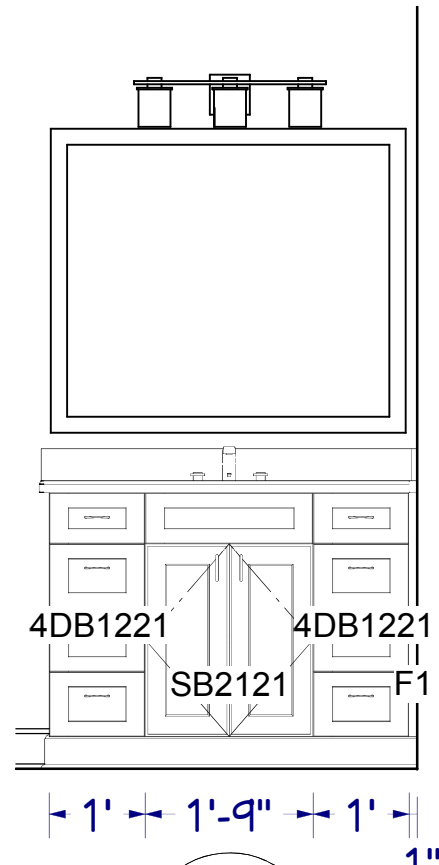


4
A3

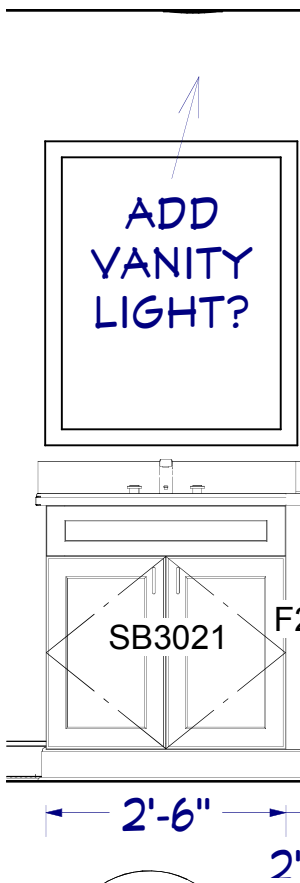


5
A3

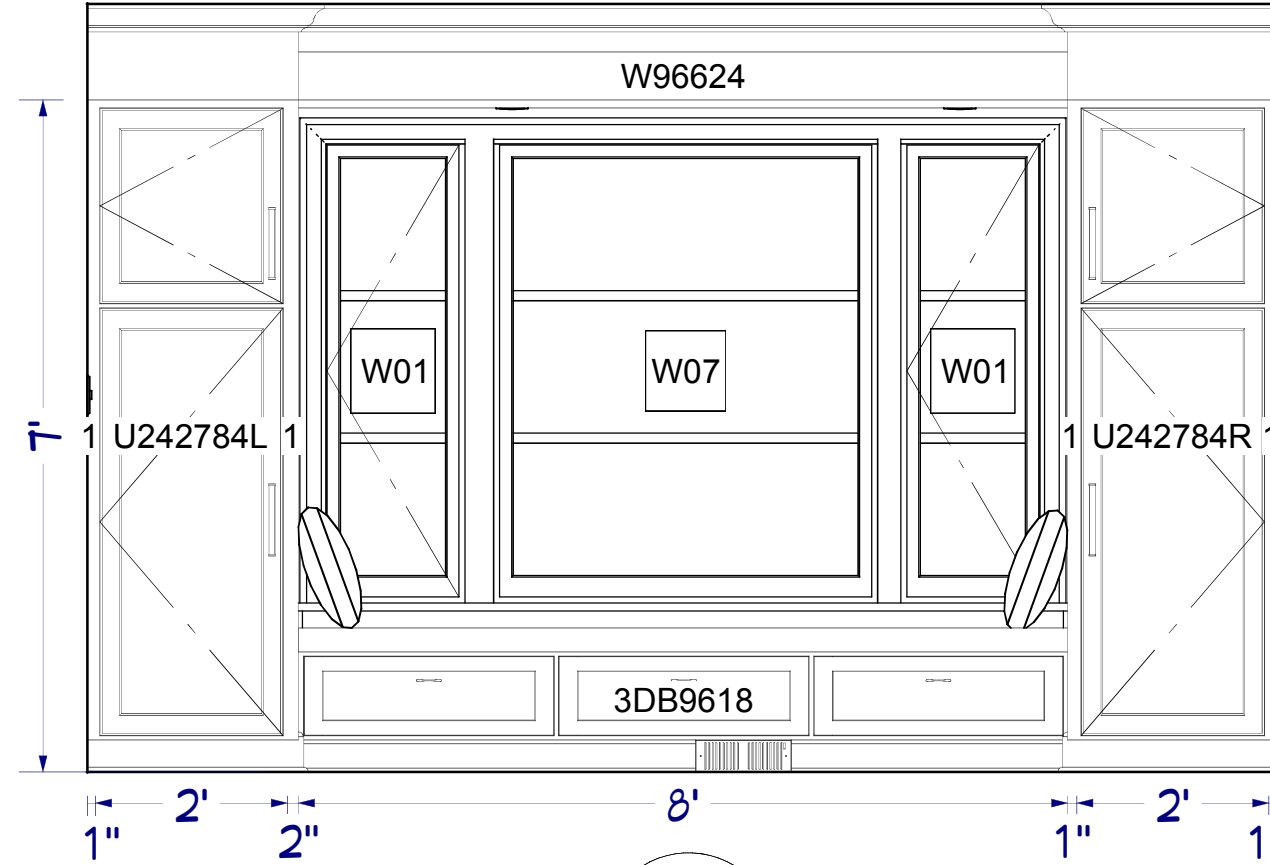


6
A3

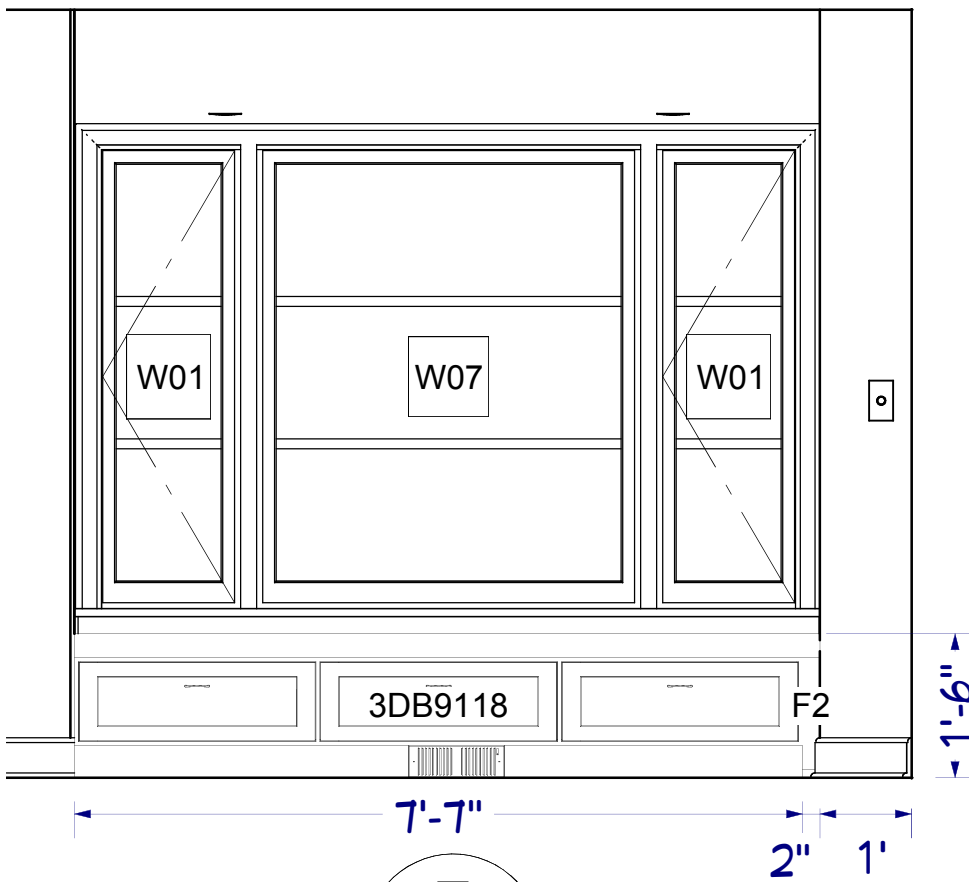

7
A3

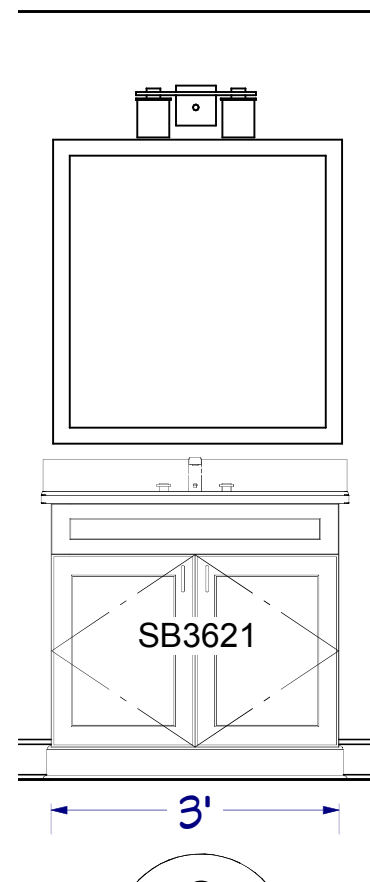


8
A3

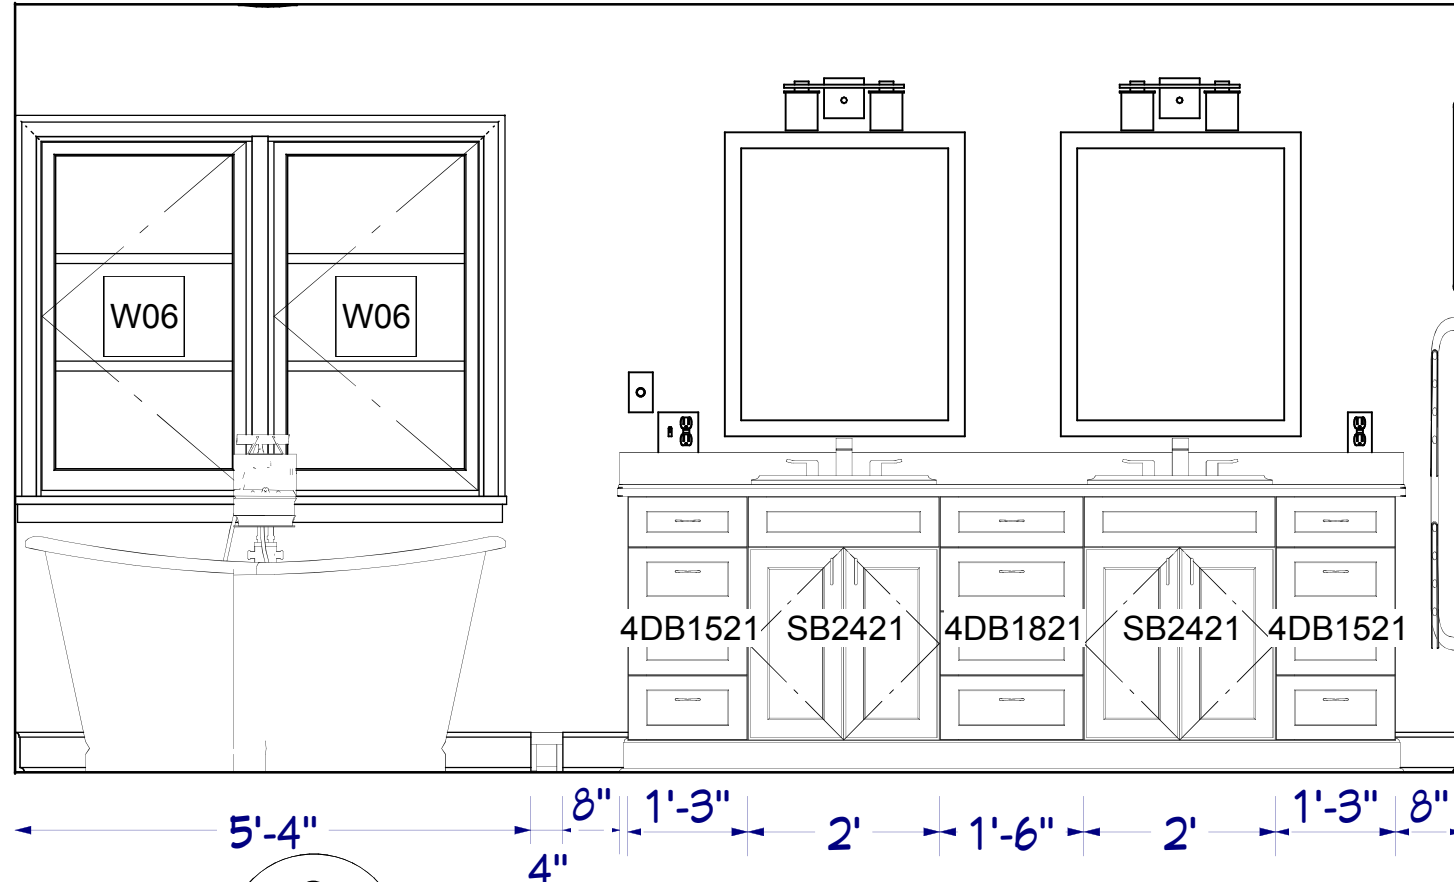

9
A3

RELEASED FOR
CONSTRUCTION

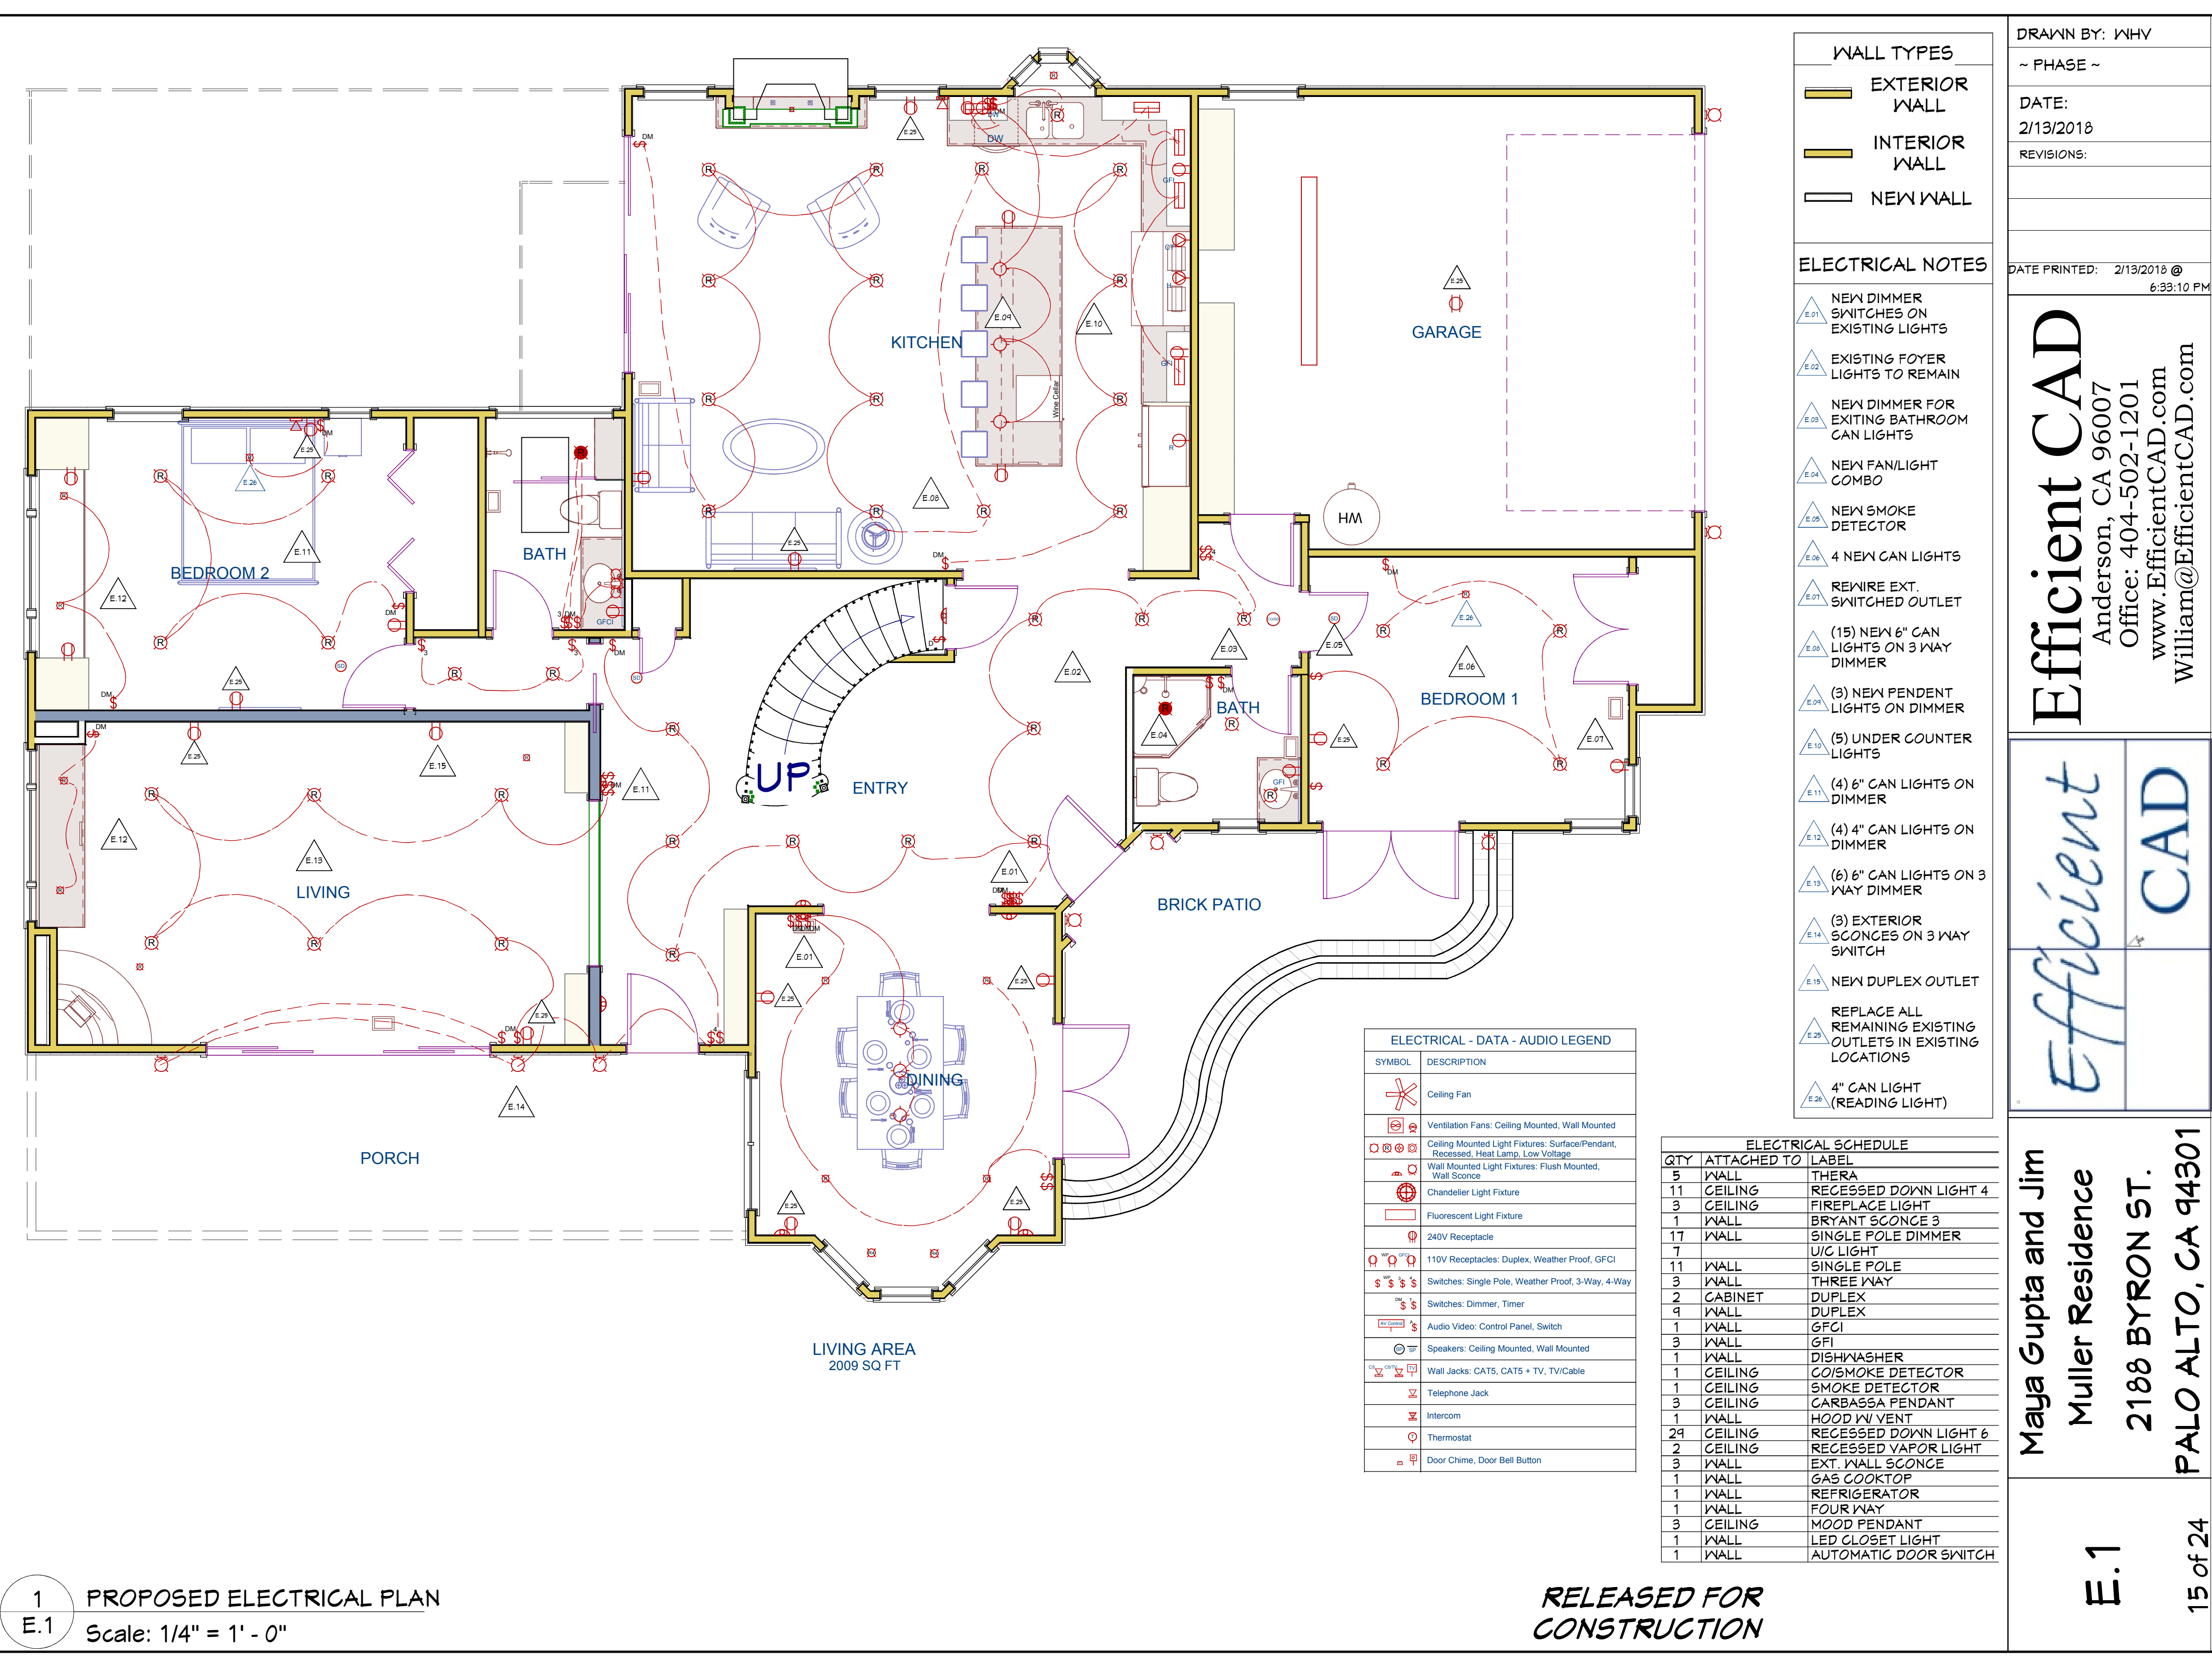

WALL TYPES	
	EXTERIOR WALL
	INTERIOR WALL
	NEW WALL

ELECTRICAL NOTES

- E.01 NEW DIMMER SWITCHES ON EXISTING LIGHTS
- E.02 EXISTING FOYER LIGHTS TO REMAIN
- E.03 NEW DIMMER FOR EXISTING BATHROOM CAN LIGHTS
- E.04 NEW FAN/LIGHT COMBO
- E.05 NEW SMOKE DETECTOR
- E.06 4 NEW CAN LIGHTS
- E.07 REWIRE EXT. SWITCHED OUTLET
- E.08 (15) NEW 6" CAN LIGHTS ON 3 WAY DIMMER
- E.09 (3) NEW PENDENT LIGHTS ON DIMMER
- E.10 (5) UNDER COUNTER LIGHTS
- E.11 (4) 6" CAN LIGHTS ON DIMMER
- E.12 (4) 4" CAN LIGHTS ON DIMMER
- E.13 (6) 6" CAN LIGHTS ON 3 WAY DIMMER
- E.14 (3) EXTERIOR SCONCES ON 3 WAY SWITCH
- E.15 NEW DUPLEX OUTLET
- E.25 REPLACE ALL REMAINING EXISTING OUTLETS IN EXISTING LOCATIONS
- E.26 4" CAN LIGHT (READING LIGHT)

ELECTRICAL - DATA - AUDIO LEGEND	
SYMBOL	DESCRIPTION
	Ceiling Fan
	Ventilation Fans: Ceiling Mounted, Wall Mounted
	Ceiling Mounted Light Fixtures: Surface/Pendant, Recessed, Heat Lamp, Low Voltage
	Wall Mounted Light Fixtures: Flush Mounted, Wall Sconce
	Chandelier Light Fixture
	Fluorescent Light Fixture
	240V Receptacle
	110V Receptacles: Duplex, Weather Proof, GFCI
	Switches: Single Pole, Weather Proof, 3-Way, 4-Way
	Switches: Dimmer, Timer
	Audio Video: Control Panel, Switch
	Speakers: Ceiling Mounted, Wall Mounted
	Wall Jacks: CAT5, CAT5 + TV, TV/Cable
	Telephone Jack
	Intercom
	Thermostat
	Door Chime, Door Bell Button

ELECTRICAL SCHEDULE		
QTY	ATTACHED TO	LABEL
5	WALL	THERA
11	CEILING	RECESSED DOWN LIGHT 4
3	CEILING	FIREPLACE LIGHT
1	WALL	BRYANT SCONCE 3
17	WALL	SINGLE POLE DIMMER
7		U/C LIGHT
11	WALL	SINGLE POLE
3	WALL	THREE WAY
2	CABINET	DUPLEX
4	WALL	DUPLEX
1	WALL	GFCI
3	WALL	GFI
1	WALL	DISHWASHER
1	CEILING	CO/SMOKE DETECTOR
1	CEILING	SMOKE DETECTOR
3	CEILING	CARBASSA PENDANT
1	WALL	HOOD W/ VENT
29	CEILING	RECESSED DOWN LIGHT 6
2	CEILING	RECESSED VAPOR LIGHT
3	WALL	EXT. WALL SCONCE
1	WALL	GAS COOKTOP
1	WALL	REFRIGERATOR
1	WALL	FOUR WAY
3	CEILING	MOOD PENDANT
1	WALL	LED CLOSET LIGHT
1	WALL	AUTOMATIC DOOR SWITCH

DRAWN BY: WHV
~ PHASE ~
DATE:
2/13/2018
REVISIONS:

DATE PRINTED: 2/13/2018 @ 6:33:10 PM


Efficient CAD
Anderson, CA 96007
Office: 404-502-1201
www.EfficientCAD.com
William@EfficientCAD.com

Efficient CAD

Maya Gupta and Jim
Muller Residence
2188 BYRON ST.
PALO ALTO, CA 94301

E.1

15 of 24

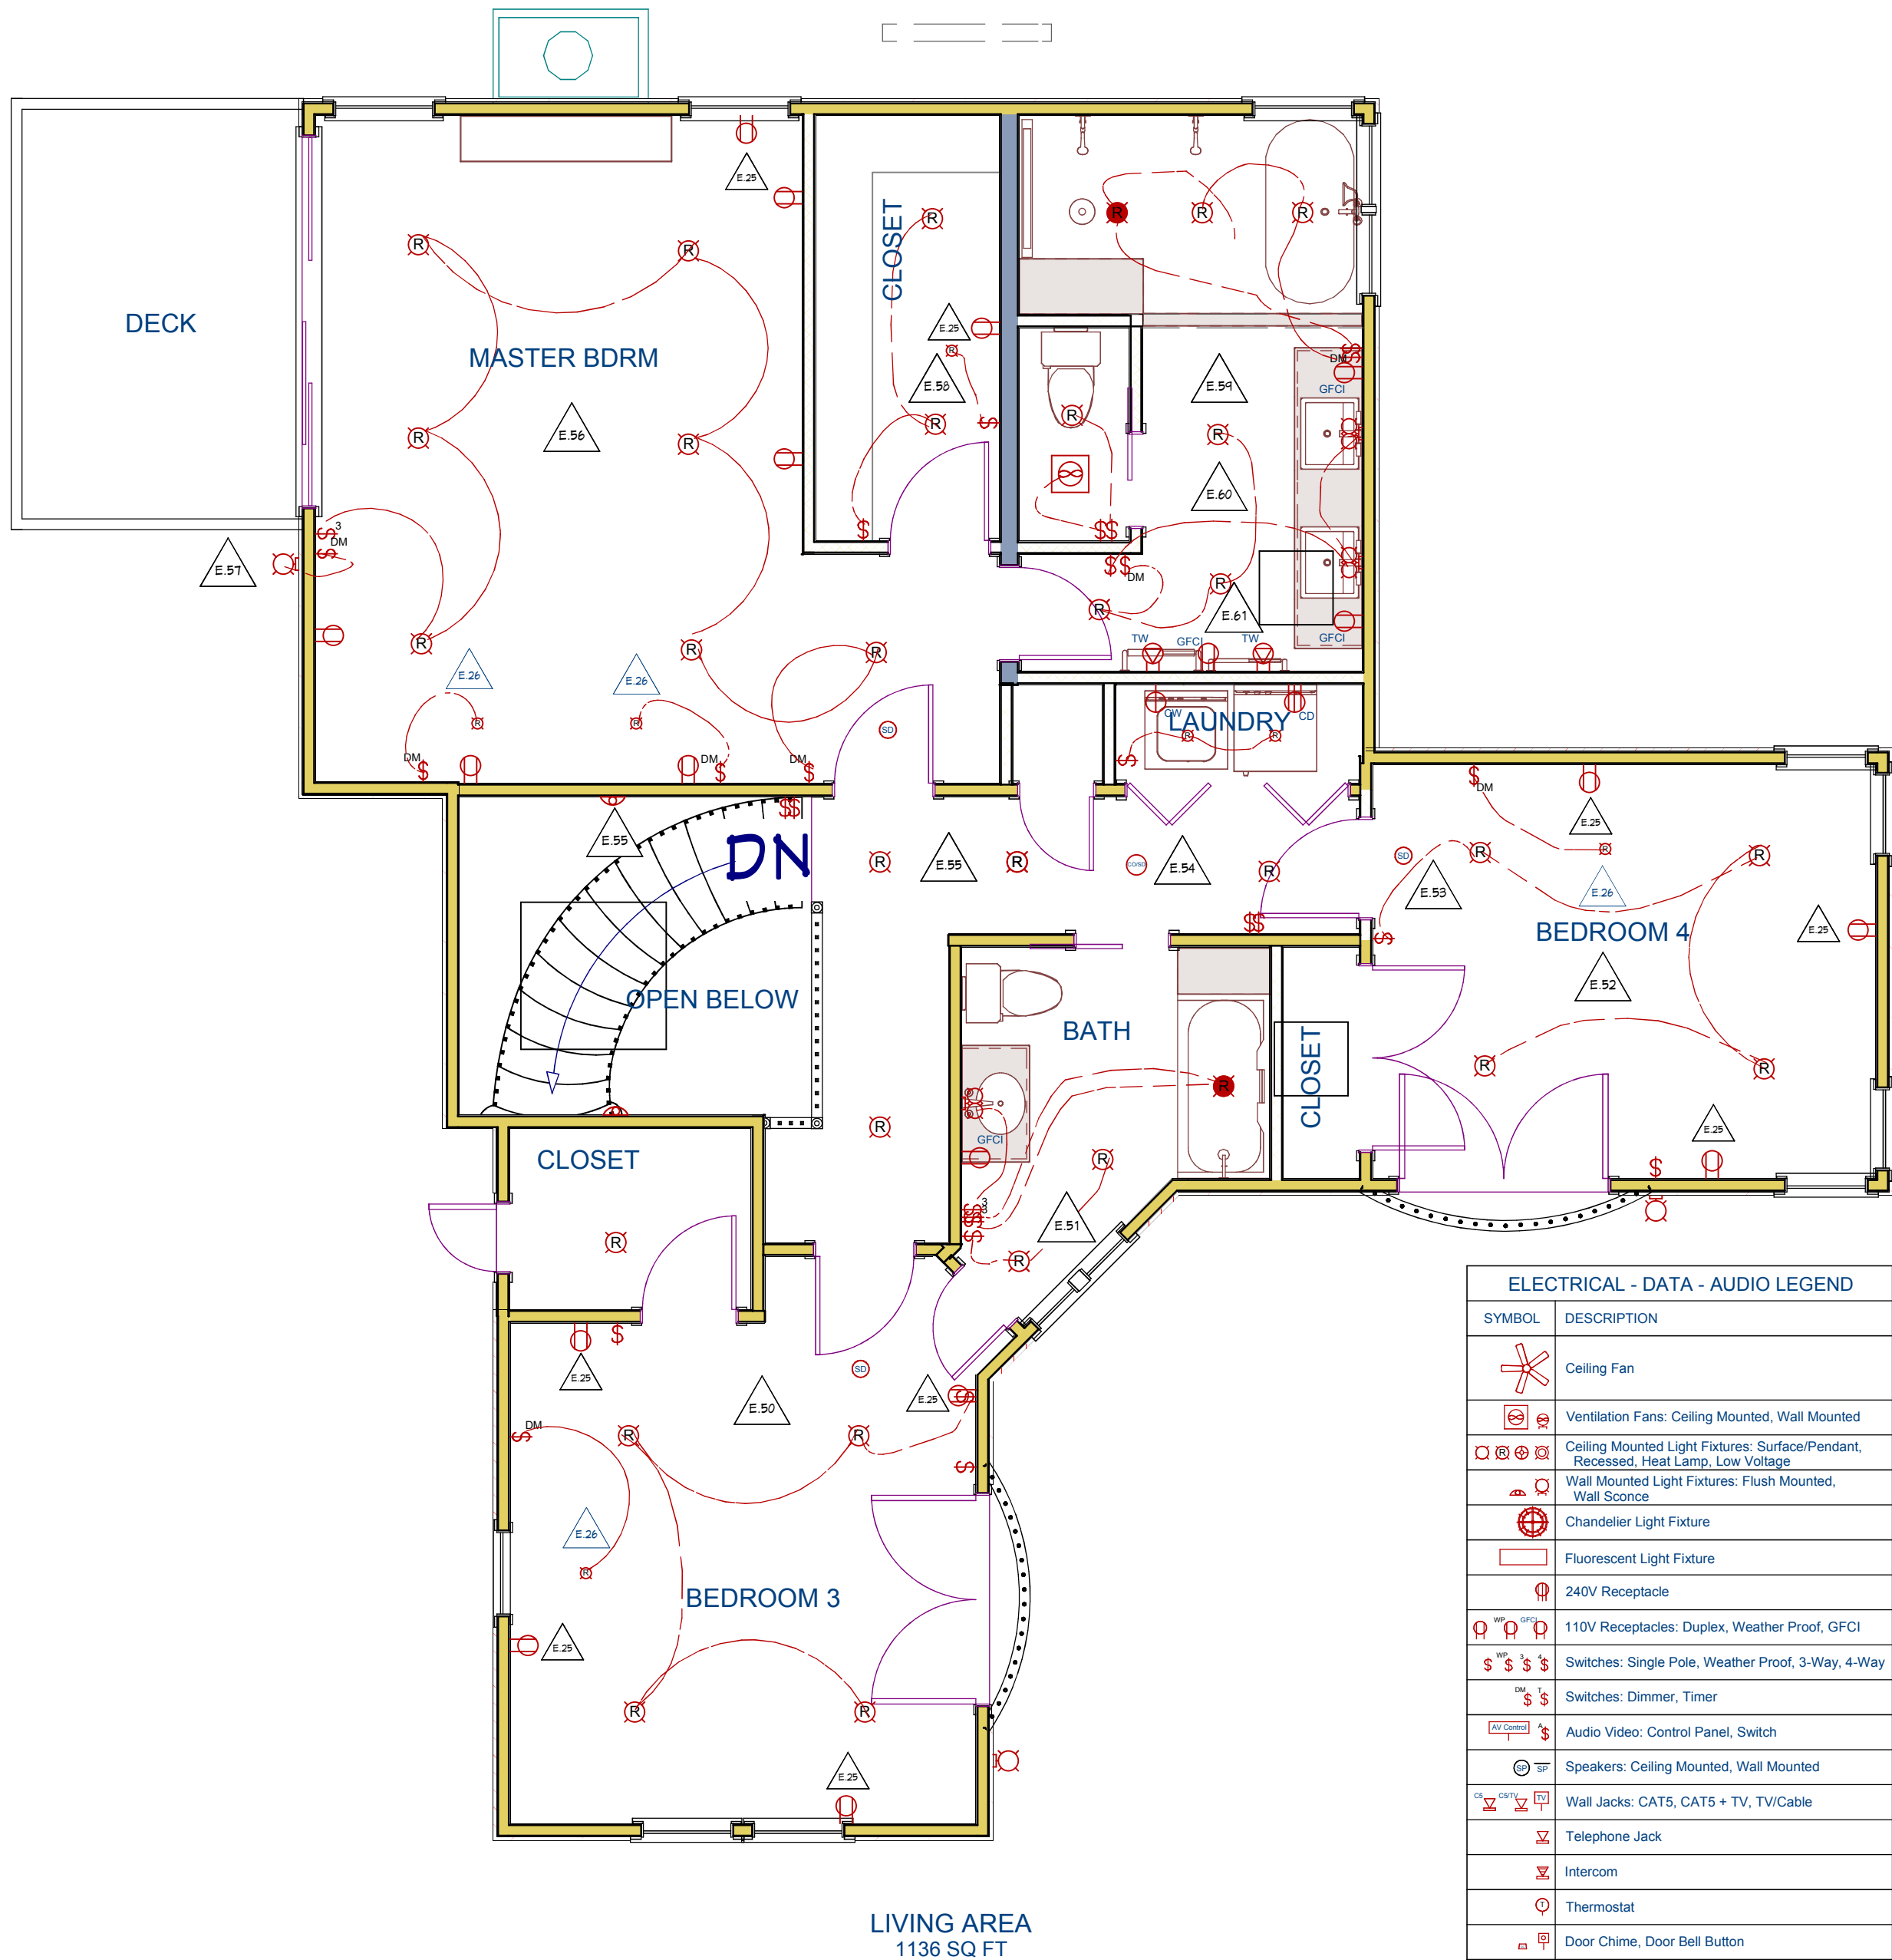

ELECTRICAL - DATA - AUDIO LEGEND	
SYMBOL	DESCRIPTION
	Ceiling Fan
	Ventilation Fans: Ceiling Mounted, Wall Mounted
	Ceiling Mounted Light Fixtures: Surface/Pendant, Recessed, Heat Lamp, Low Voltage
	Wall Mounted Light Fixtures: Flush Mounted, Wall Sconce
	Chandelier Light Fixture
	Fluorescent Light Fixture
	240V Receptacle
	110V Receptacles: Duplex, Weather Proof, GFCI
	Switches: Single Pole, Weather Proof, 3-Way, 4-Way
	Switches: Dimmer, Timer
	Audio Video: Control Panel, Switch
	Speakers: Ceiling Mounted, Wall Mounted
	Wall Jacks: CAT5, CAT5 + TV, TV/Cable
	Telephone Jack
	Intercom
	Thermostat
	Door Chime, Door Bell Button
	Smoke Detectors: Ceiling Mounted, Wall Mounted
	Electrical Breaker Panel

ELECTRICAL SCHEDULE		
QTY	ATTACHED TO	LABEL
1	CEILING	EXHAUST
24	CEILING	RECESSED DOWN LIGHT 6
2	CEILING	RECESSED VAPOR LIGHT
2	CEILING	SMOKE DETECTOR
3	WALL	THREE WAY
8	WALL	SINGLE POLE DIMMER
3	WALL	SCONCE 2
5	WALL	DUPLEX
1	WALL	EXT. WALL SCONCE
11	WALL	SINGLE POLE
4	WALL	GFCI
7	CEILING	RECESSED DOWN LIGHT 4
1	CEILING	CO/SMOKE DETECTOR
1	WALL	CLOTHES WASHER
1	WALL	CLOTHES DRYER
2	WALL	TOWEL WARMER

WALL TYPES

EXTERIOR WALL

INTERIOR WALL

NEW WALL

ELECTRICAL NOTES

(4) CAN LIGHTS ON NEW DIMMER

EXISTING (2) CAN LIGHTS ON NEW DIMMER

(4) CAN LIGHTS

NEW SMOKE DETECTOR

NEW SMOKE/CO DETECTOR

EXISTING STAIR/HALL LIGHTS TO REMAIN

(7) CAN LIGHTS ON 3 WAY DIMMER

NEW EXT. SCONCE TO MATCH EXISTING

(2) CAN LIGHTS

(3) CAN LIGHTS

(2) TALL TOWEL WARMERS

HEATED FLOORS IN ALL BATHROOMS ON PROGRAMMABLE SWITCH

REPLACE ALL REMAINING EXISTING OUTLETS IN EXISTING LOCATIONS

4" CAN LIGHT (READING LIGHT)

ALL SWITCHES TO BE LUTRON TYP.

DRAWN BY: WHV

~ PHASE ~

DATE:
2/13/2018

REVISIONS:

DATE PRINTED: 2/13/2018 @
6:33:11 PM

Efficient CAD

Anderson, CA 96007

Office: 404-502-1201

www.EfficientCAD.com

William@EfficientCAD.com

Efficient

CAD

Maya Gupta and Jim

Muller Residence

2188 BYRON ST.

PALO ALTO, CA 94301

E.2

16 of 24



PROPOSED FRONT PORCH
VERSION 1



PROPOSED KITCHEN
VERSION 1

DRAWN BY: WHV

~ PHASE ~

DATE:
2/13/2018

REVISIONS:

DATE PRINTED: 2/13/2018 @
6:33:11 PM

Efficient CAD
Anderson, CA 96007
Office: 404-502-1201
www.EfficientCAD.com
William@EfficientCAD.com

Efficient

CAD

Maya Gupta and Jim
Muller Residence
2188 BYRON ST.
PALO ALTO, CA 94301

R.2

18 of 24


1
R2

PROPOSED RENDERING
Scale: N/A

RELEASED FOR
CONSTRUCTION



Efficient CAD
Anderson, CA 96007
Office: 404-502-1201
www.EfficientCAD.com
William@EfficientCAD.com

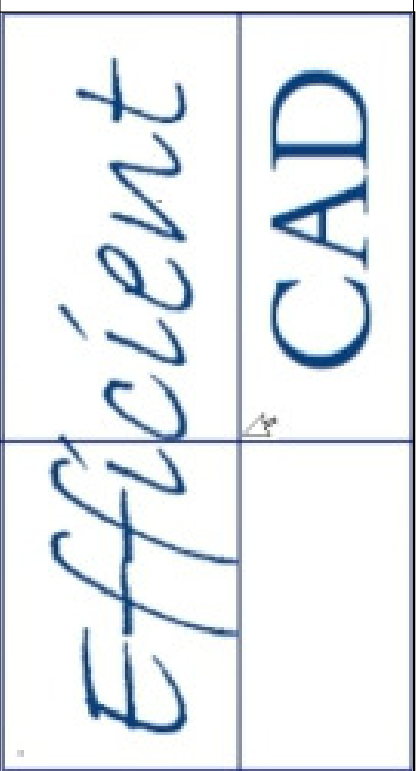

Maya Gupta and Jim
Muller Residence
2188 BYRON ST.
PALO ALTO, CA 94301

R.3
19 of 24


PROPOSED KITCHEN
VERSION 1



PROPOSED KITCHEN
VERSION 1

DRAWN BY: WHV
~ PHASE ~
DATE: 2/13/2018
REVISIONS:
DATE PRINTED: 2/13/2018 @ 6:33:12 PM

Efficient CAD
Anderson, CA 96007
Office: 404-502-1201
www.EfficientCAD.com
William@EfficientCAD.com

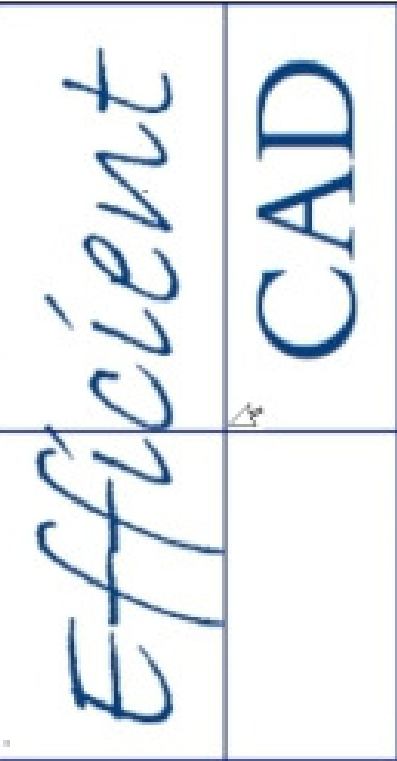

Maya Gupta and Jim
Muller Residence
2188 BYRON ST.
PALO ALTO, CA 94301

R.4

20 of 24

RELEASED FOR
CONSTRUCTION



BEDROOM 2
WINDOW SEAT/ BOOKCASE

DRAWN BY: WHV
~ PHASE ~
DATE: 2/13/2018
REVISIONS:
DATE PRINTED: 2/13/2018 @ 6:33:12 PM

Efficient CAD

Anderson, CA 96007
Office: 404-502-1201
www.EfficientCAD.com
William@EfficientCAD.com

Efficient

CAD

Maya Gupta and Jim
Muller Residence
2188 BYRON ST.
PALO ALTO, CA 94301

R.5


21 of 24



PROPOSED MASTER BATH
VERSION 1

DRAWN BY: WHV
~ PHASE ~
DATE: 2/13/2018
REVISIONS:
DATE PRINTED: 2/13/2018 @ 6:33:12 PM

Efficient CAD
Anderson, CA 96007
Office: 404-502-1201
www.EfficientCAD.com
William@EfficientCAD.com

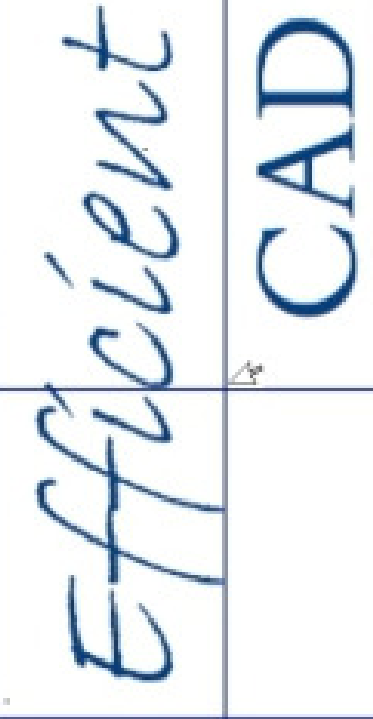

Maya Gupta and Jim
Muller Residence
2188 BYRON ST.
PALO ALTO, CA 94301

R.6

22 of 24



PROPOSED MASTER BATH
VERSION 1

DRAWN BY: WHV
~ PHASE ~
DATE:
2/13/2018
REVISIONS:
DATE PRINTED: 2/13/2018 @
6:33:12 PM

Efficient CAD
Anderson, CA 96007
Office: 404-502-1201
www.EfficientCAD.com
William@EfficientCAD.com

Efficient
CAD

Maya Gupta and Jim
Muller Residence
2188 BYRON ST.
PALO ALTO, CA 94301

R.7

23 of 24

RELEASED FOR
CONSTRUCTION